


DOCUMENT REFERENCE:

NOTES:-

1. EXISTING LAYOUT AND SURVEY TAKEN FROM SSE DRG No: 277_1104_0006_00_00.
2. GT2 TO BE REMOVED POST-OUTAGE
3. GT1 TO BE REMOVED DURING OUTAGE TO ALLOW FOR NEW 33KV BAY AND 132KV CSE

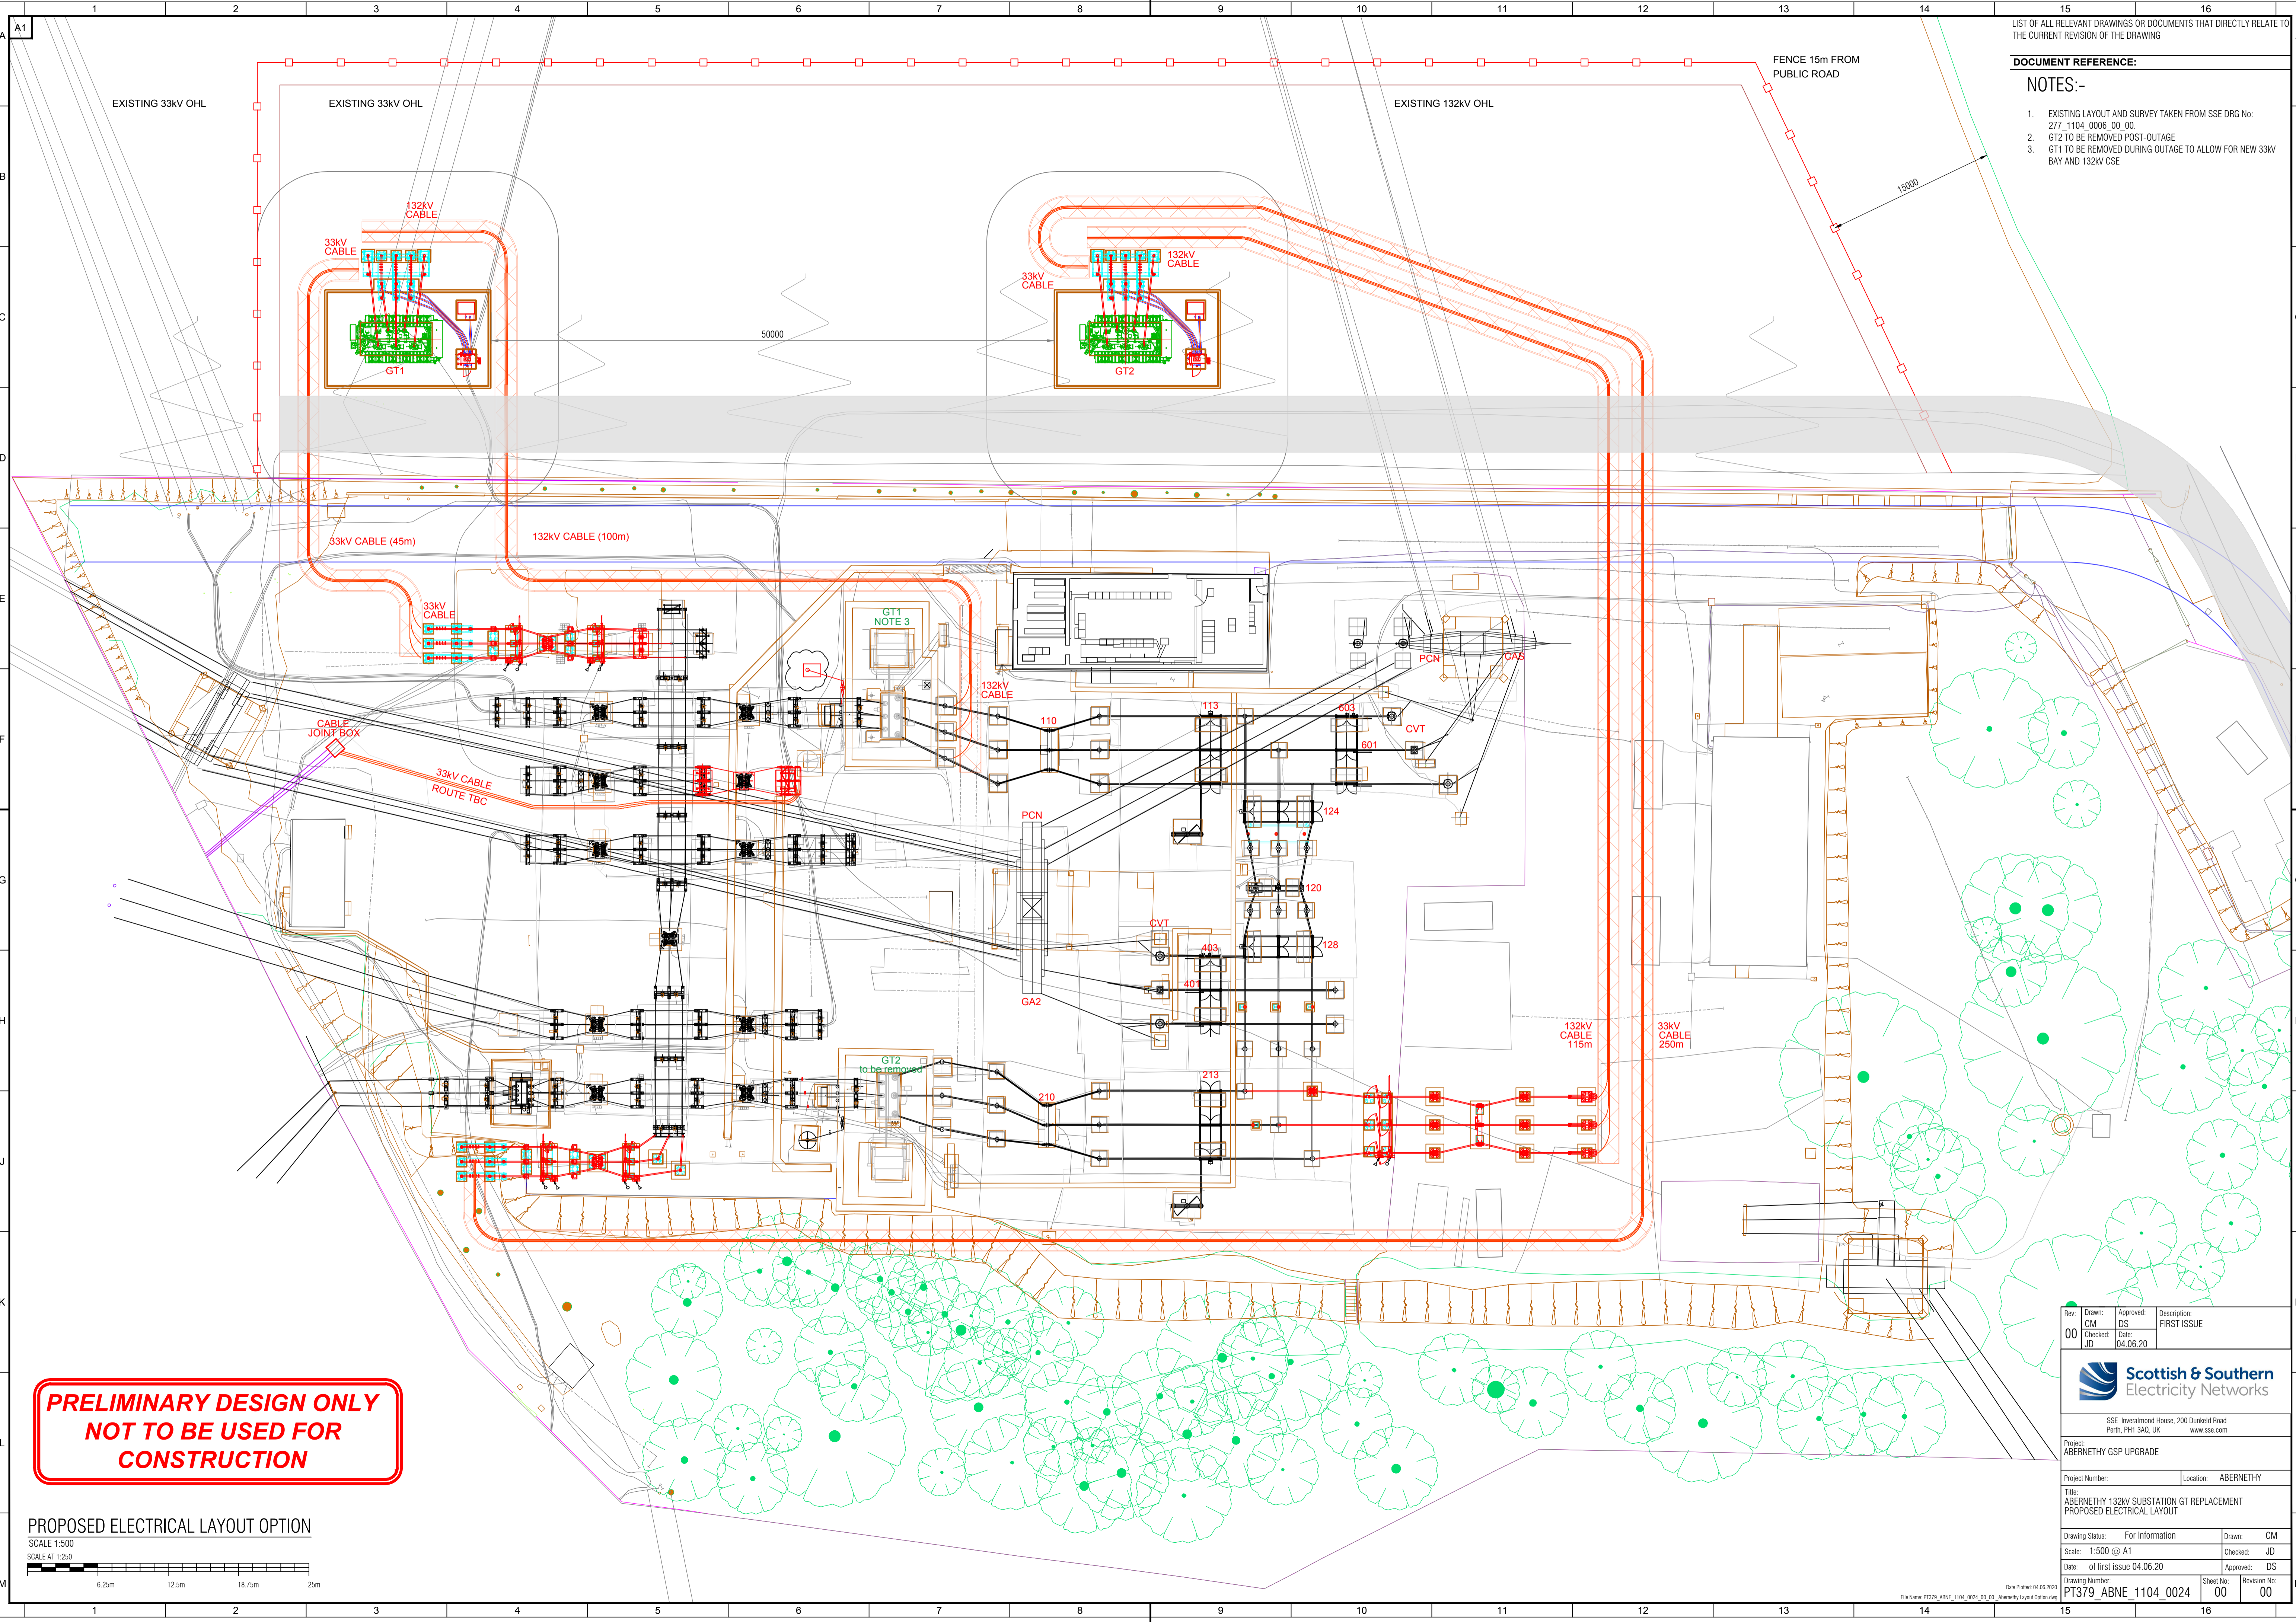

**PRELIMINARY DESIGN ONLY
NOT TO BE USED FOR
CONSTRUCTION**

PROPOSED ELECTRICAL LAYOUT OPTION

SCALE 1:500
SCALE AT 1:250

Rev: 00	Drawn: CM	Approved: DS	Description: FIRST ISSUE
	Checked: JD	Date: 04.06.20	



Project: ABERNETHY GSP UPGRADE		Location: ABERNETHY	
Title: ABERNETHY 132KV SUBSTATION GT REPLACEMENT PROPOSED ELECTRICAL LAYOUT			
Drawing Status: For Information	Drawn: CM		
Scale: 1:500 @ A1	Checked: JD		
Date: of first issue 04.06.20	Approved: DS		
Drawing Number: PT379_ABNE_1104_0024	Sheet No: 00	Revision No: 00	