


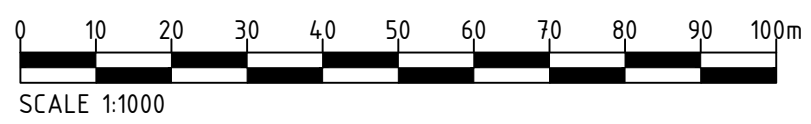
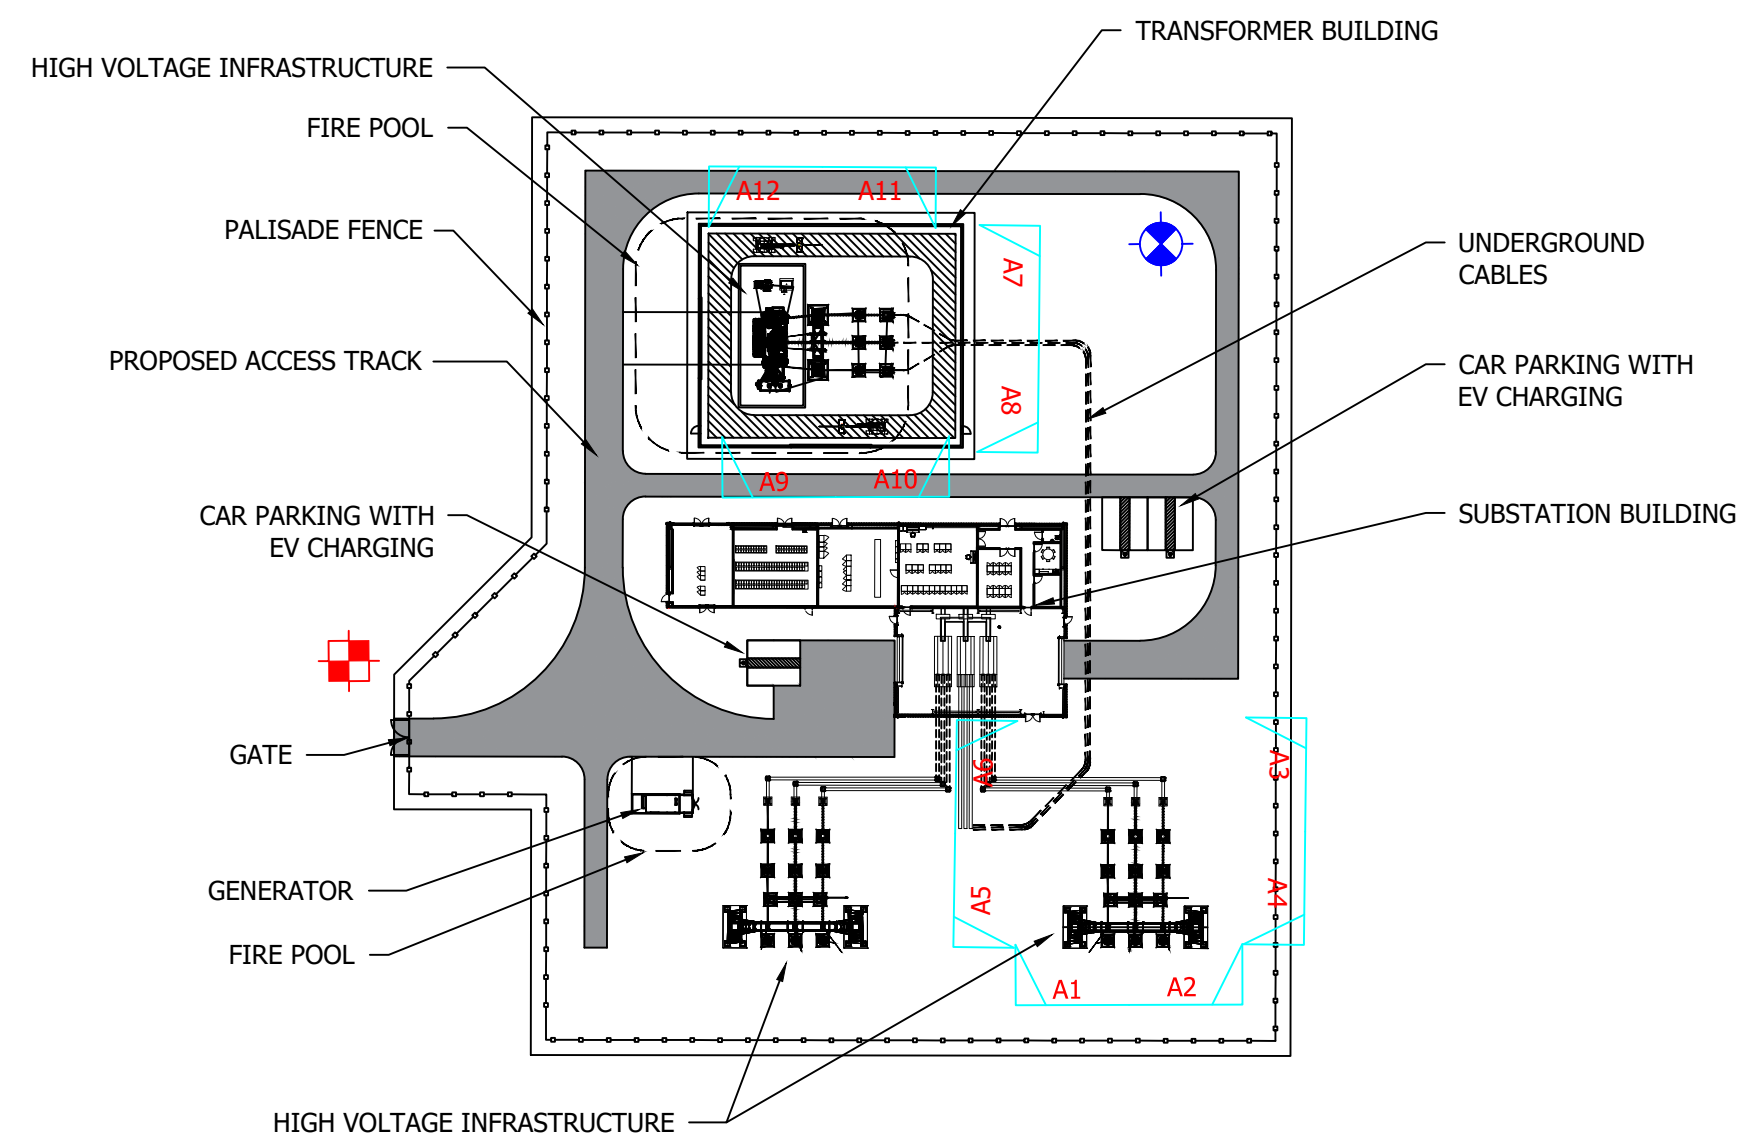


KEY

-  BOREHOLE WATER SUPPLY
-  SEPTIC TANK
-  ELECTRICAL LAYOUT REF. SEE FIGURE 6 (4534a-DR-P-0011 & 0013) FOR ELEVATION DETAIL.




NOTE:

PRE-DEV SITE LEVELS
- 158-179mAOD

POST-DEV SITE LEVELS
- 174mAOD

Plot Date : 08 September 2022 12:15:05
File Name : Y:\CAD\4534 ARGYLL SUBSTATIONS\01-WORKING\01_01-DRAWINGS\4534A-AN SUIDHE TOWN & COUNTRY PLANNING APPLICATION\4534A-DR-P-0004-P2 - SUBSTATION COMPOUND LAYOUT

Project Title AN SUIDHE SUBSTATION	Drawing Title PLANNING FIGURE 003b SUBSTATION COMPOUND LAYOUT & ELECTRICAL SECTION LOCATIONS	Purpose of issue PLANNING				THIS DOCUMENT HAS BEEN PREPARED IN ACCORDANCE WITH THE SCOPE OF ARCUS' APPOINTMENT WITH ITS CLIENT AND IS SUBJECT TO THE TERMS OF THAT APPOINTMENT. ARCUS ACCEPTS NO LIABILITY FOR ANY USE OF THIS DOCUMENT OTHER THAN BY ITS CLIENT AND ONLY FOR THE PURPOSES FOR WHICH IT WAS PREPARED AND PROVIDED	Arcus Consultancy Services 7th Floor 144 West George Street Glasgow, G2 2HG Tel: +44 (0)141 221 9997 Fax: +44 (0)141 221 5610 www.arcusconsulting.co.uk
		Designed -	Drawn RC	Checked RC	Approved DB		
Client 		Arcus Internal Project No. 4534		Date 06/09/22		Drawing Number 4534a-DR-P-0004	Rev 2
		Scale @ A3 1:1000					

