


This map is based upon Ordnance Survey material with the permission of Ordnance Survey on behalf of the Controller of His Majesty's Stationary Office © Crown copyright and database rights 2024 Ordnance Survey 0100031673. Any unauthorised reproduction infringes Crown copyright and may lead to prosecution or civil proceedings.

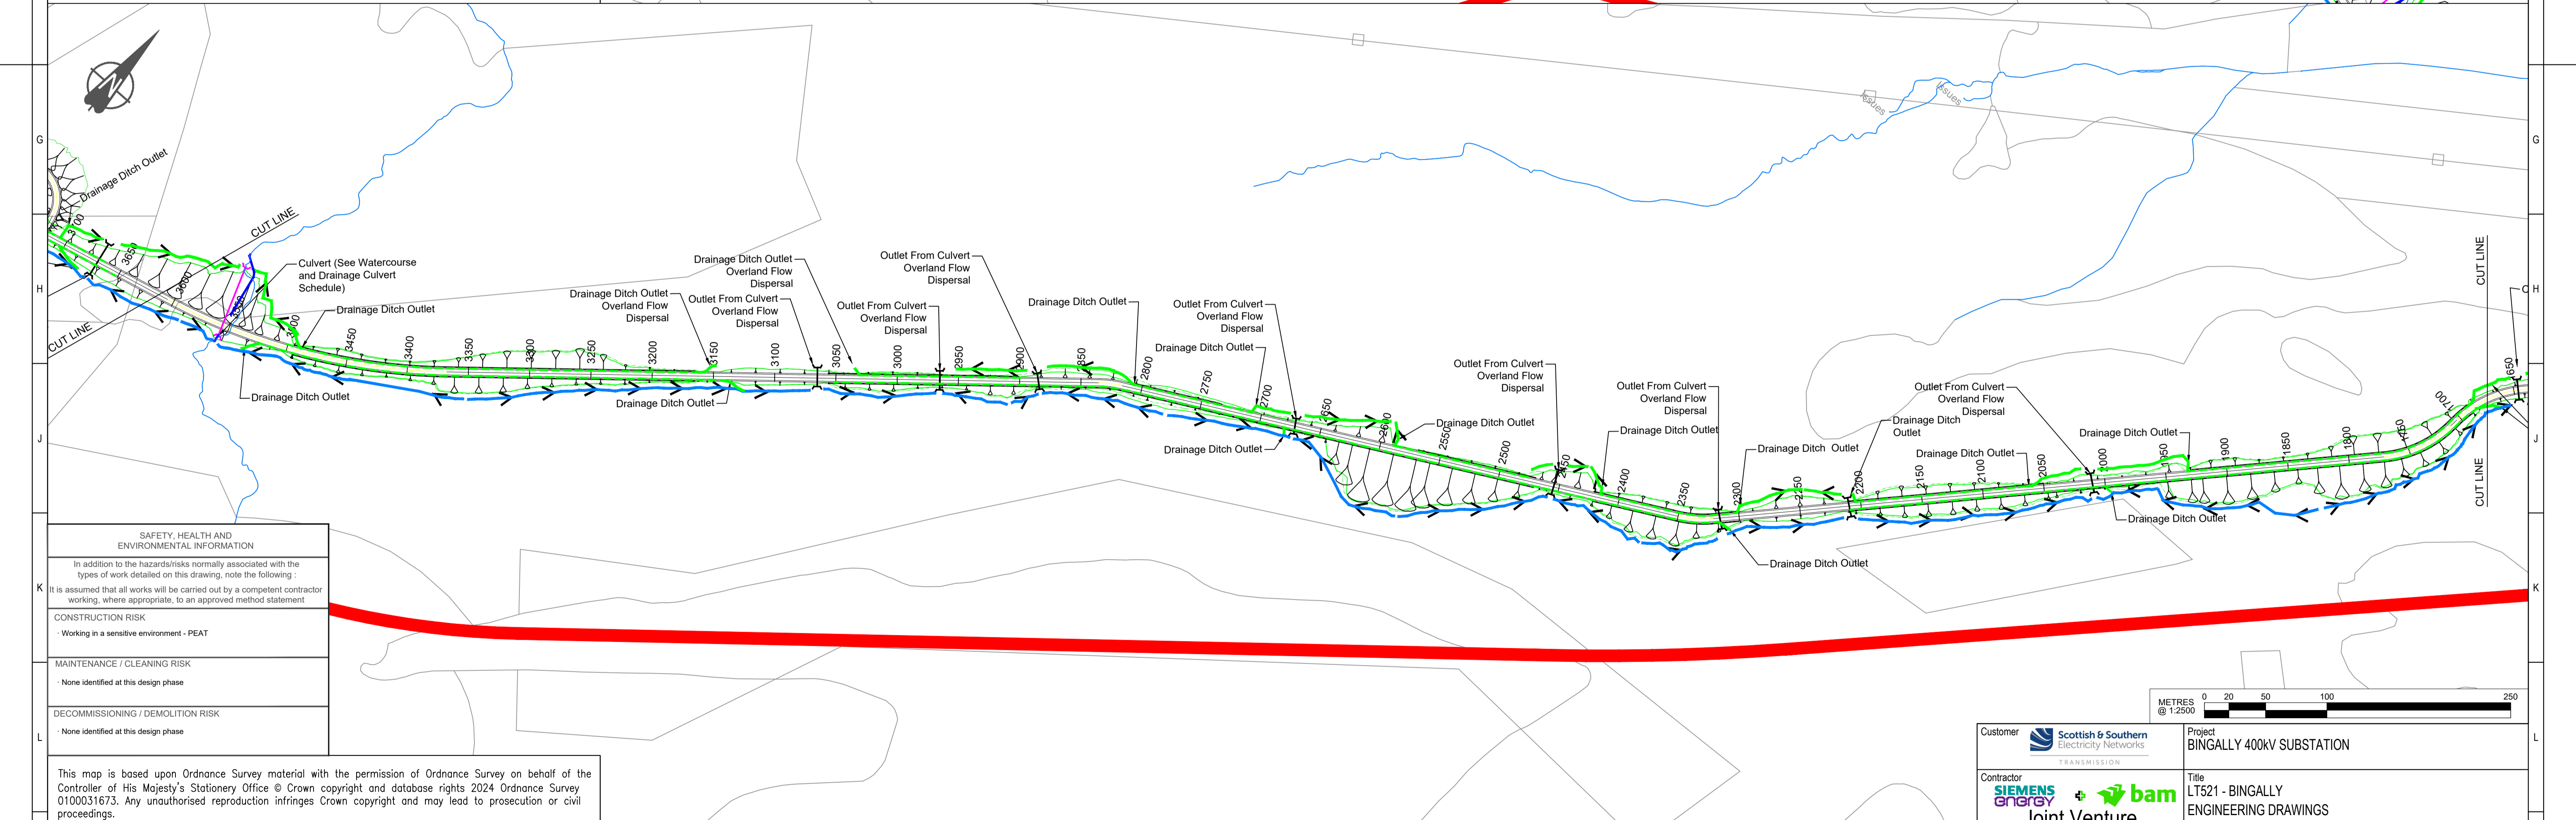


This map is based upon Ordnance Survey material with the permission of Ordnance Survey on behalf of the Controller of His Majesty's Stationary Office © Crown copyright and database rights 2024 Ordnance Survey 0100031673. Any unauthorised reproduction infringes Crown copyright and may lead to prosecution or civil proceedings.

SAFETY, HEALTH AND ENVIRONMENTAL INFORMATION	
In addition to the hazards/risks normally associated with the types of work detailed on this drawing, note the following:	
It is assumed that all works will be carried out by a competent contractor working, where appropriate, to an approved method statement.	
CONSTRUCTION RISK	
Working in a sensitive environment - PEAT	
MAINTENANCE / CLEANING RISK	
None identified at this design phase	
DECOMMISSIONING / DEMOLITION RISK	
None identified at this design phase	

REVISION:	P01.1
DRAWN:	J.PETRIE 03/09/2024
CHECKED:	R.DUNCAN 03/09/2024
APPROVED:	R.MINTO 03/09/2024
PROJECT REF: BING4-LT521	
FIRST ISSUE: 04/09/2024	

- NOTES
1. DITCH DIMENSIONS ARE PRELIMINARY ONLY AND TO BE FINALISED AT DETAILED DESIGN UPON COORDINATION WITH EARTHWORKS AND CULVERT DESIGNS.
 2. DITCH SIZES REFER TO CAPACITY REQUIREMENTS ONLY. ADDITIONAL CUT AND FILL MAY BE REQUIRED TO GRADE EXISTING GROUND.
 3. SETTLEMENT LAGOON EXTENTS SHOWN TO NOT INCLUDE EARTHWORKS EXTENTS.
 4. DURING CONSTRUCTION PARTICULAR CARE IS TO BE TAKEN BY THE CONTRACTOR TO ENSURE THAT THE MINIMUM AMOUNT OF DAMAGE AND DISTURBANCE TO LAND DRAINS AND DITCHES ARE CAUSED. THE CONTRACTOR WILL INVESTIGATE, DESIGN, INSTALL, REPAIR AND MAINTAIN ALL LAND DRAINS THAT ARE AFFECTED BY THE WORKS AS PER THE CIVIL SCOPE OF WORKS. COORDINATION OF DRAINAGE DESIGN AND CABLE COORDINATES TO BE CONFIRMED.

LEGEND:	
	TYPE A OR TYPE B HIGHSIDE DITCH AS INDICATED ON ACCOMPANYING SPREADSHEET
	SWALE
	DRAINAGE DITCH (PERMANENT TRACK)
	DRAINAGE CULVERT
	WATERCOURSE CULVERT
	SUSTAINABLE URBAN DRAINAGE SYSTEM
	WATERCOURSE REALIGNMENT

 

Customer		Project	BINGALLY 400KV SUBSTATION		
Contractor		Title	LT521 - BINGALLY ENGINEERING DRAWINGS PROPOSED TRACK DRAINAGE LAYOUT SHEET 2		
Subcon. Drawing No.		Contractor Drawing No.	BING4-LT521-SEBAM-DRAI-ZZ-D-C-0192		
BING4-LT521-SEBAM-DRAI-ZZ-D-C-0192		Customer Drawing No.	BING4-LT521-SEBAM-DRAI-ZZ-D-C-0192		
Designed	J.PETRIE	Drawn	S.MITCHELL	Checked	R.DUNCAN
Approved	R.MINTO	Date	03/09/2024	Scale	1:2500
Sheet	2	of	3	Revision	P01.1