
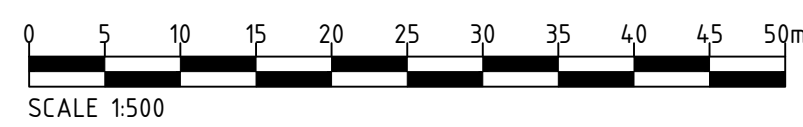


KEY	
	BOREHOLE WATER SUPPLY
	SEPTIC TANK
	ELECTRICAL LAYOUT REF. SEE FIGURE 6 (4534b-DR-P-0011, 0014 & 0015) FOR ELEVATION DETAIL.

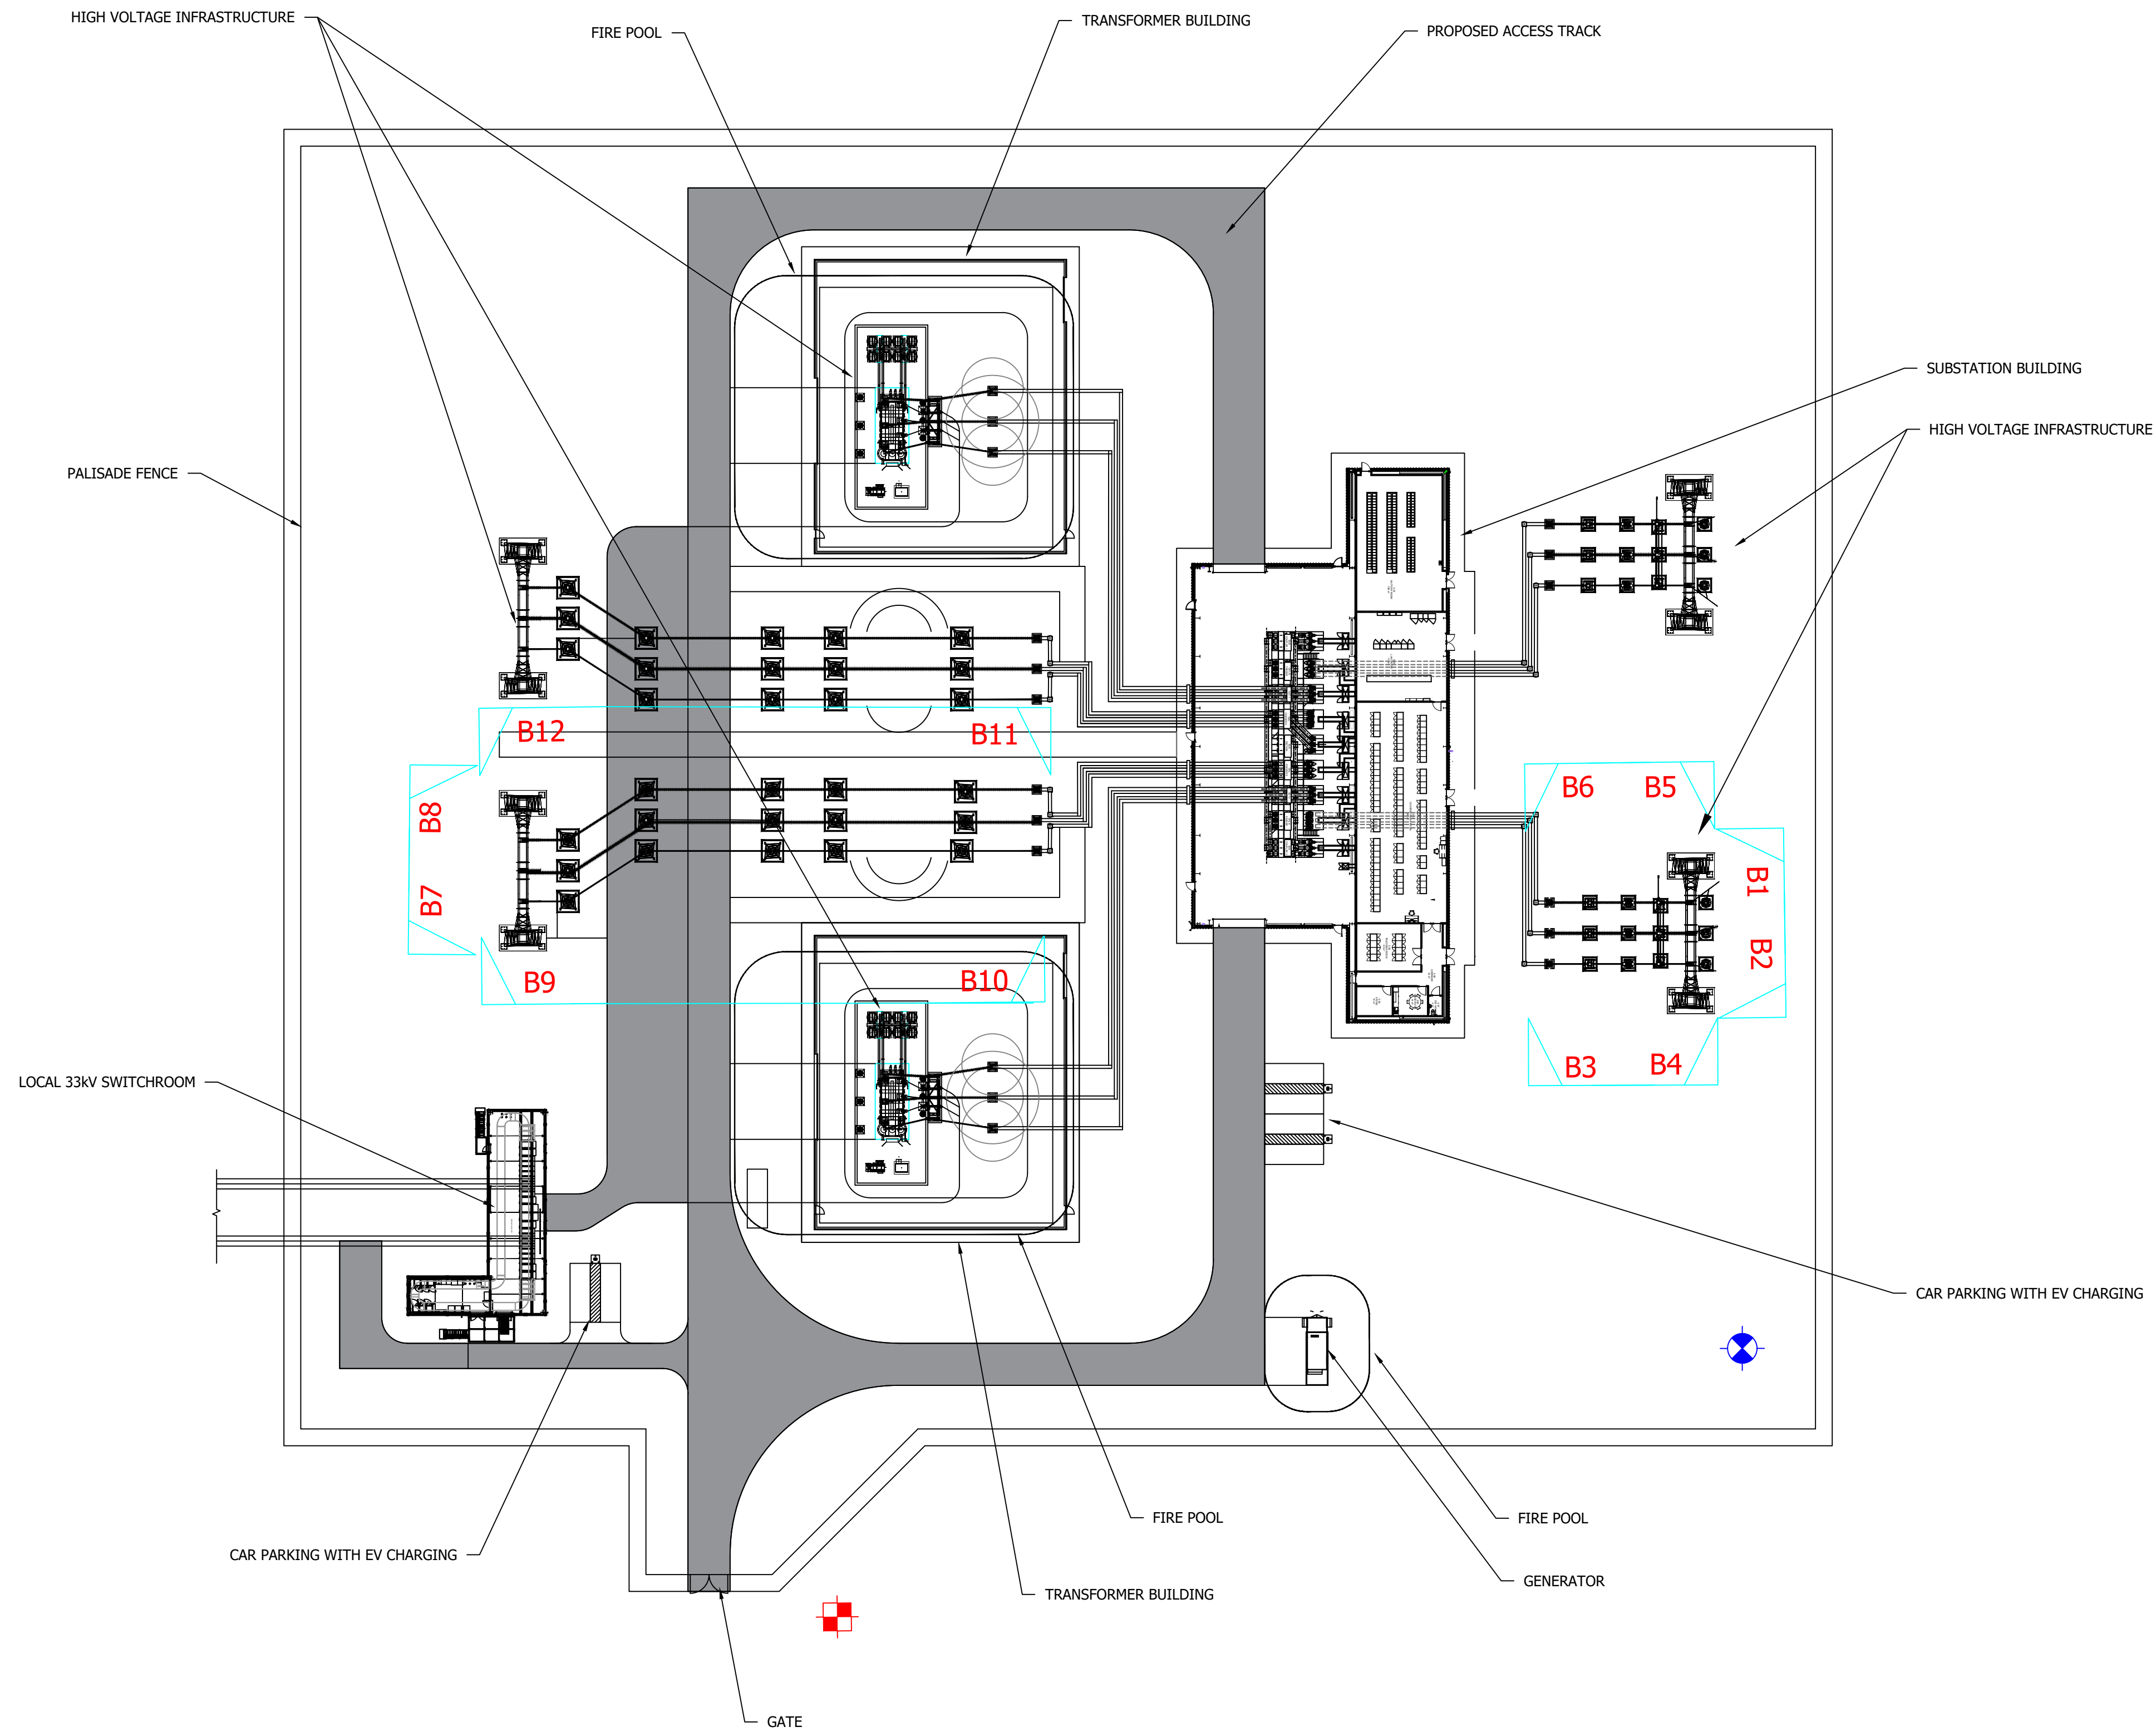

NOTE:
 PRE-DEV SITE LEVELS
 - 109-123mAOD
 POST-DEV SITE LEVELS
 - 115mAOD

Plot Date: 10 January 2023 17:04:59
 File Name: Y:\CAD\534 ARCS\ALL SUBSTATIONS\01 WORKING\01_01 DRAWINGS\4534b CRAIG MURRAIL TOWN & COUNTRY PLANNING APPLICATION\4534b-DR-P-004-P3 - SUBSTATION COMPOUND LAYOUT

Client Purpose of Issue PLANNING THIS DRAWING IS TO BE USED ONLY FOR THE PURPOSE OF ISSUE THAT IT WAS ISSUED FOR AND IS SUBJECT TO AMENDMENT. SAFETY, HEALTH AND ENVIRONMENTAL INFORMATION BOX		NOTES 1. THIS DRAWING IS TO BE READ IN CONJUNCTION WITH ALL OTHER RELEVANT DOCUMENTATION. 2. DO NOT SCALE FROM THIS DRAWING. USE ONLY PRINTED DIMENSIONS. 3. ALL DIMENSIONS, CHANGES, LEVELS AND COORDINATES ARE IN METRES UNLESS DEFINED OTHERWISE. 4. THIS DRAWING IS TO BE READ IN CONJUNCTION WITH THE PROJECT HEALTH & SAFETY FILE FOR ANY IDENTIFIED POTENTIAL RISKS.		Project Title CRAIG MURRAIL SUBSTATION		Drawing Title PLANNING FIGURE 003b SUBSTATION COMPOUND LAYOUT & ELECTRICAL SECTION LOCATIONS		Designed - Arcus Internal Project No. 4534 Scale @ A1 1:500		Drawn SR Checked RC Approved RC Date 10.01.23		Arcus Consultancy Services 7th Floor 144 West George Street Glasgow, G2 2HG Tel: +44 (0)141 221 9997 Fax: +44 (0)141 221 5610 www.arcusconsulting.co.uk		Drawing Number 4534b-DR-P-0004		Rev 3	
Revision Details By / Check / Date / Rev																	

THIS DOCUMENT HAS BEEN PREPARED IN ACCORDANCE WITH THE SCOPE OF ARCUS' APPOINTMENT WITH ITS CLIENT AND IS SUBJECT TO THE TERMS OF THAT APPOINTMENT. ARCUS ACCEPTS NO LIABILITY FOR ANY USE OF THIS DOCUMENT OTHER THAN BY ITS CLIENT AND ONLY FOR THE PURPOSES FOR WHICH IT WAS PREPARED AND PROVIDED.