

HIGH VOLTAGE INFRASTRUCTURE

UNDERGROUND CABLES

CAR PARKING WITH EV CHARGING

FIRE POOL


GENERATOR

FIRE POOL

PALISADE FENCE

PROPOSED ACCESS TRACK

GATE

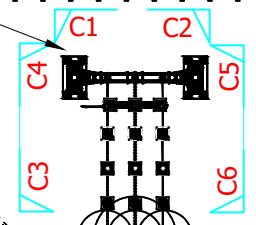

SUBSTATION BUILDING

UNDERGROUND CABLES

TRANSFORMER BUILDING

KEY



 
BOREHOLE WATER SUPPLY



SEPTIC TANK



ELECTRICAL LAYOUT REF. SEE FIGURE 6 (4534c-DR-P-0011) FOR ELEVATION DETAIL.





SCALE 1:1000

NOTE:

PRE-DEV SITE LEVELS
- 163-180m AOD

POST-DEV SITE LEVELS
- 173m AOD

Plot Date: 01 December 2022 11:06:34
File Name: Y:\CAD\4534 ARGYLL SUBSTATIONS\01-WORKING\01_01-DRAWINGS\4534C_CRARAE\TOWN & COUNTRY PLANNING APPLICATION\4534C-DR-P-0004-P3 - SUBSTATION COMPOUND LAYOUT

Project Title <p align="center">CRARAE SUBSTATION</p>		Drawing Title <p align="center">PLANNING FIGURE 003b SUBSTATION COMPOUND LAYOUT & ELECTRICAL SECTION LOCATIONS</p>				Purpose of issue <p align="center">PLANNING</p>				<p>THIS DOCUMENT HAS BEEN PREPARED IN ACCORDANCE WITH THE SCOPE OF ARCUS' APPOINTMENT WITH ITS CLIENT AND IS SUBJECT TO THE TERMS OF THAT APPOINTMENT. ARCUS ACCEPTS NO LIABILITY FOR ANY USE OF THIS DOCUMENT OTHER THAN BY ITS CLIENT AND ONLY FOR THE PURPOSES FOR WHICH IT WAS PREPARED AND PROVIDED</p>				Arcus Consultancy Services 7th Floor 144 West George Street Glasgow, G2 2HG Tel: +44 (0)141 221 9997 Fax: +44 (0)141 221 5610 www.arcusconsulting.co.uk		
Client 		Designed - Arcus Internal Project No. 4534 Scale @ A3 1:1000		Drawn RC		Checked RC		Approved DB						Date 25/10/22		