
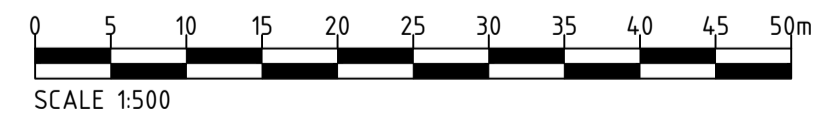


KEY	
	BOREHOLE WATER SUPPLY
	SEPTIC TANK
	ELECTRICAL LAYOUT REF. SEE FIGURE 6 (4534d-DR-P-0011) FOR ELEVATION DETAIL.

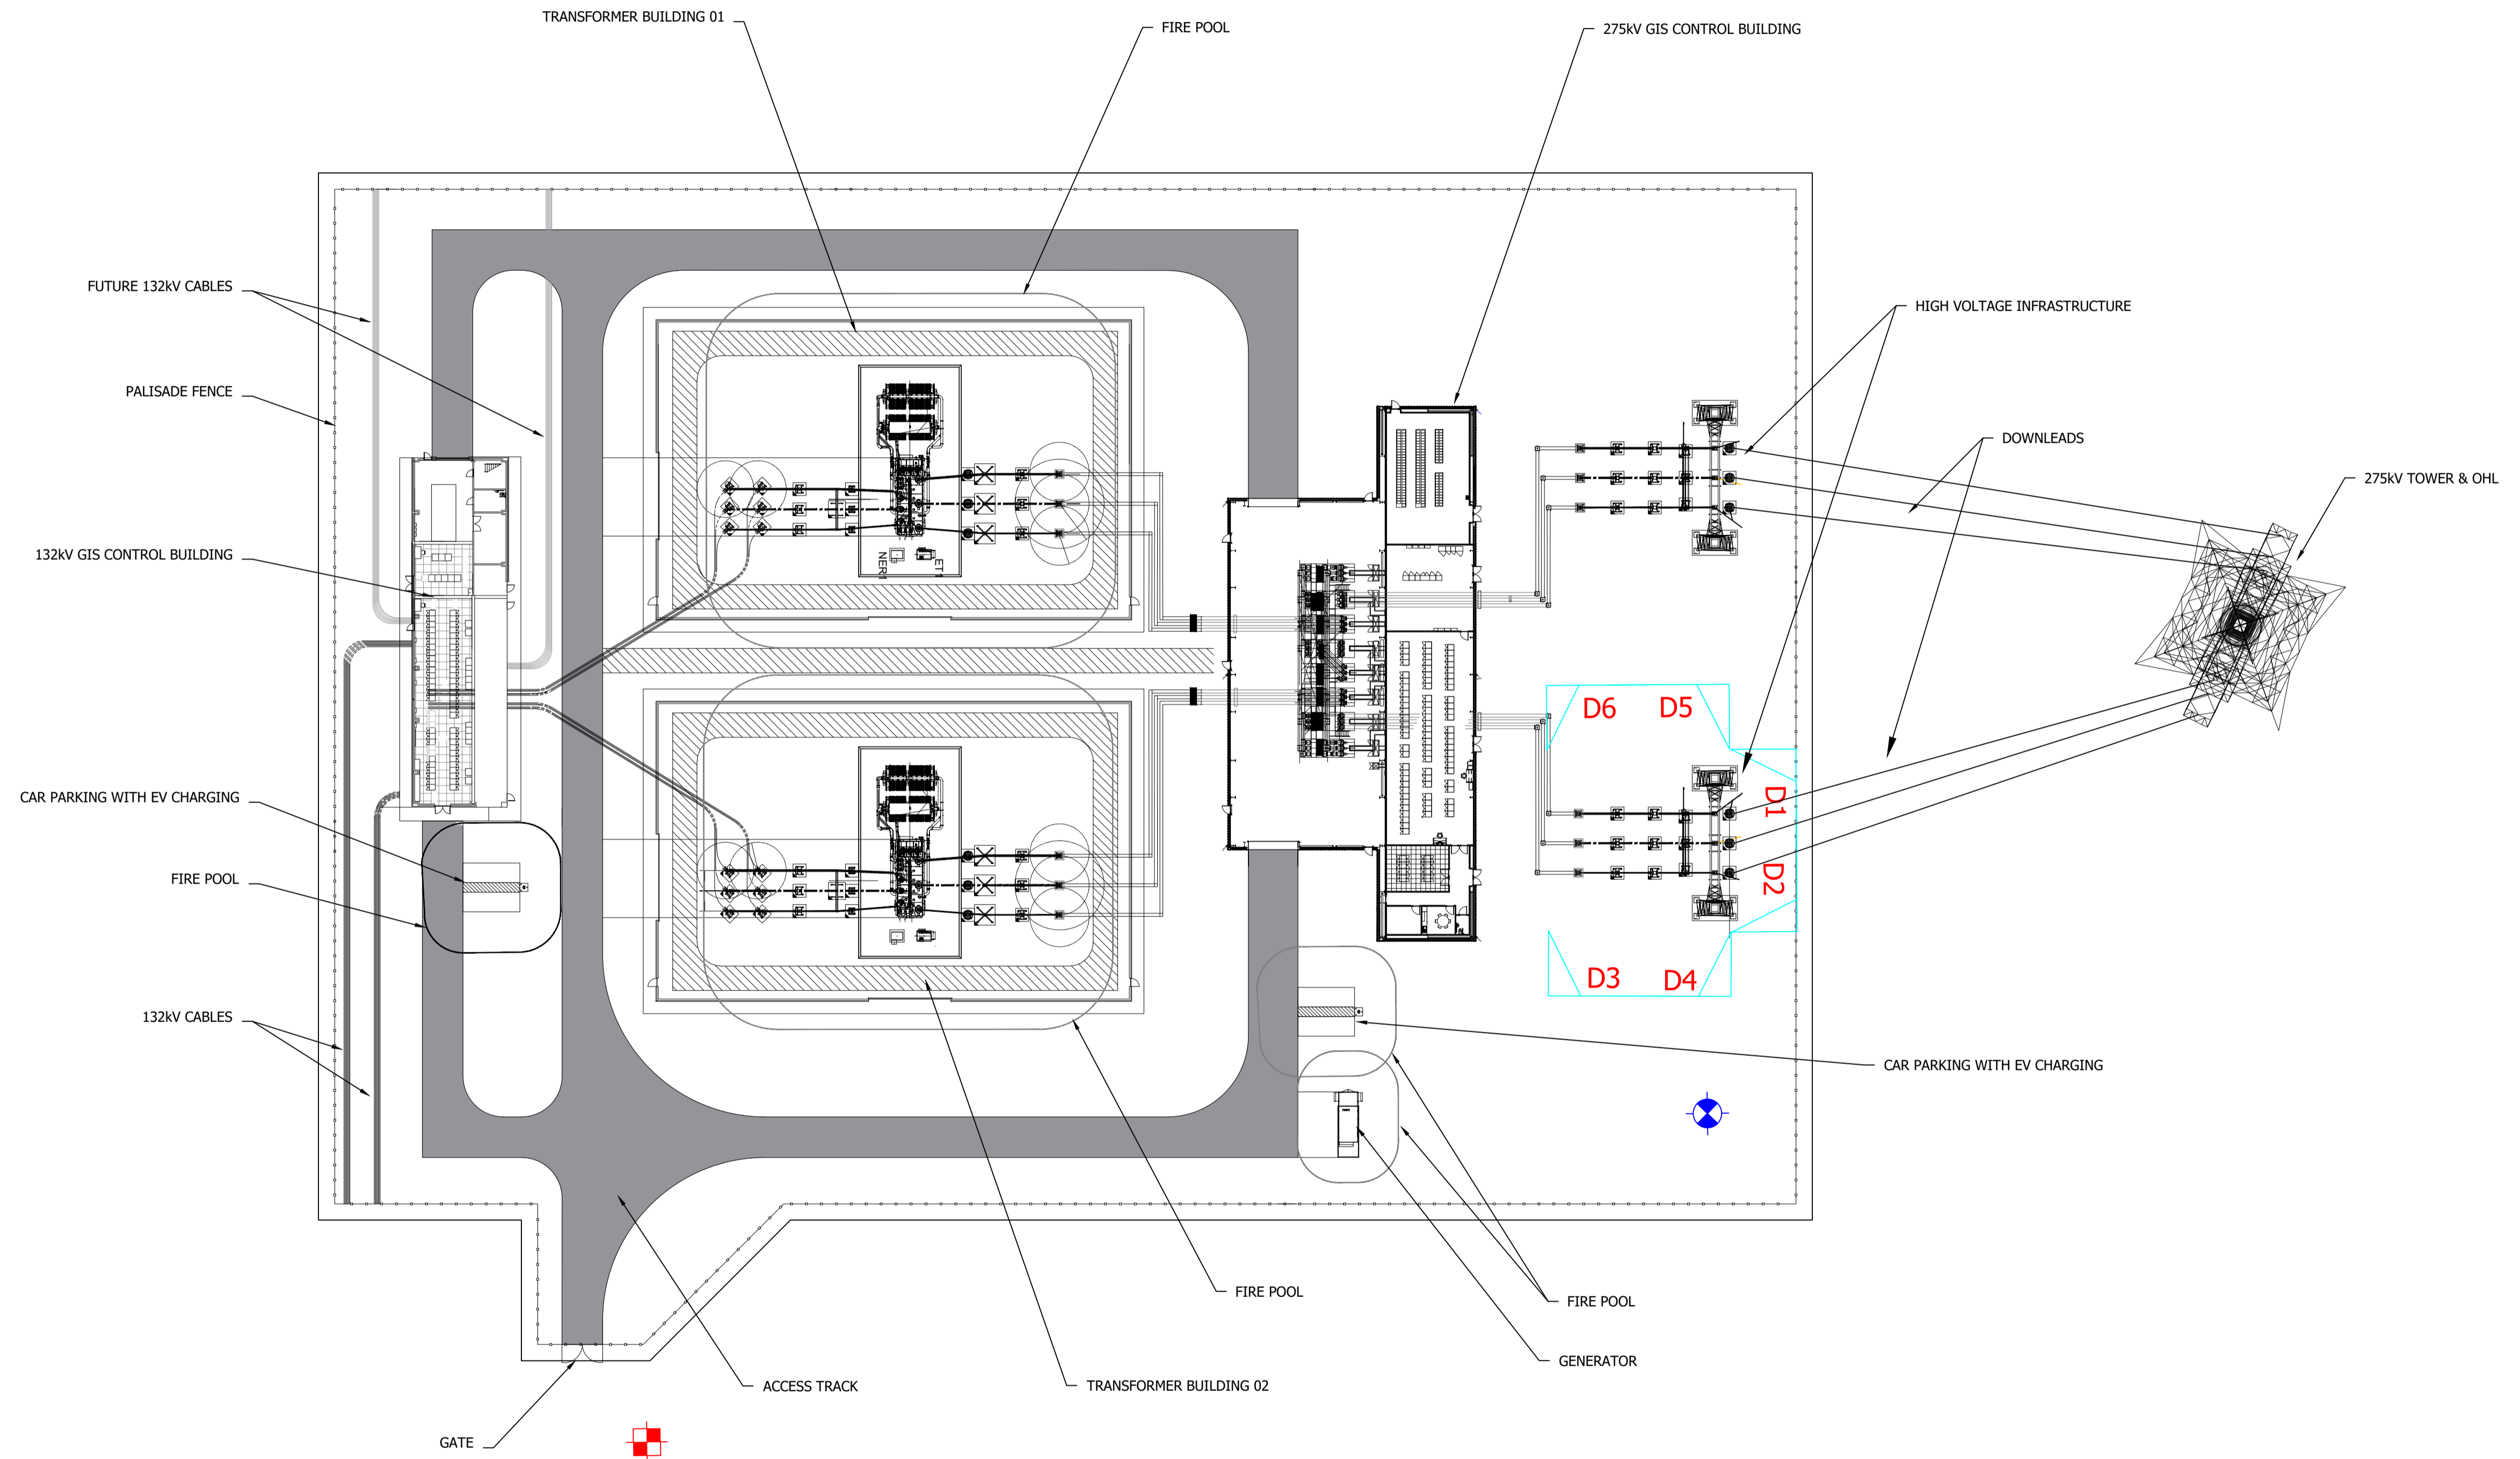

NOTE:  
 PRE-DEV SITE LEVELS  
 - 76-90m AOD  
 POST-DEV SITE LEVELS  
 - 81m AOD

Plot Date: 08 February 2023 16:13:13  
 File Name: Y:\CAD\534 ARCS\ALL SUBSTATIONS\01 WORKING\01\_01 DRAWINGS\534\4534D-DR-P-0004 P2 - SUBSTATION COMPOUND LAYOUT

		Client Scottish & Southern Electricity Networks TRANSMISSION	Purpose of Issue <b>PLANNING</b> THIS DRAWING IS TO BE USED ONLY FOR THE PURPOSE OF ISSUE THAT IT WAS ISSUED FOR AND IS SUBJECT TO AMENDMENT. SAFETY, HEALTH AND ENVIRONMENTAL INFORMATION BOX	NOTES 1. THIS DRAWING IS TO BE READ IN CONJUNCTION WITH ALL OTHER RELEVANT DOCUMENTATION. 2. DO NOT SCALE FROM THIS DRAWING. USE ONLY PRINTED DIMENSIONS. 3. ALL DIMENSIONS, CHANGES, LEVELS AND COORDINATES ARE IN METRES UNLESS DEFINED OTHERWISE. 4. THIS DRAWING IS TO BE READ IN CONJUNCTION WITH THE PROJECT HEALTH & SAFETY FILE FOR ANY IDENTIFIED POTENTIAL RISKS.	Project Title <b>CROSSAIG NORTH SUBSTATION</b>	Drawing Title <b>PLANNING FIGURE 003b SUBSTATION COMPOUND LAYOUT &amp; ELECTRICAL SECTION LOCATIONS</b>	<table border="1"> <tr> <td>Designed -</td> <td>Drawn SR</td> <td>Checked RC</td> <td>Approved RC</td> </tr> <tr> <td colspan="2">Arcus Internal Project No. 4534</td> <td colspan="2">Date 10.01.23</td> </tr> <tr> <td colspan="2">Scale @ A1 1:500</td> <td colspan="2"></td> </tr> </table>	Designed -	Drawn SR	Checked RC	Approved RC	Arcus Internal Project No. 4534		Date 10.01.23		Scale @ A1 1:500				Arcus Consultancy Services 7th Floor 144 West George Street Glasgow, G2 2HG Tel: +44 (0)141 221 9997 Fax: +44 (0)141 221 5610 <a href="http://www.arcusconsulting.co.uk">www.arcusconsulting.co.uk</a>	Drawing Number <b>4534d-DR-P-0004</b>	Rev <b>2</b>
Designed -	Drawn SR	Checked RC	Approved RC																			
Arcus Internal Project No. 4534		Date 10.01.23																				
Scale @ A1 1:500																						

THIS DOCUMENT HAS BEEN PREPARED IN ACCORDANCE WITH THE SCOPE OF ARCUS' APPOINTMENT WITH ITS CLIENT AND IS SUBJECT TO THE TERMS OF THAT APPOINTMENT. ARCUS ACCEPTS NO LIABILITY FOR ANY USE OF THIS DOCUMENT OTHER THAN BY ITS CLIENT AND ONLY FOR THE PURPOSES FOR WHICH IT WAS PREPARED AND PROVIDED.