


740

735000m.N

335000m.E

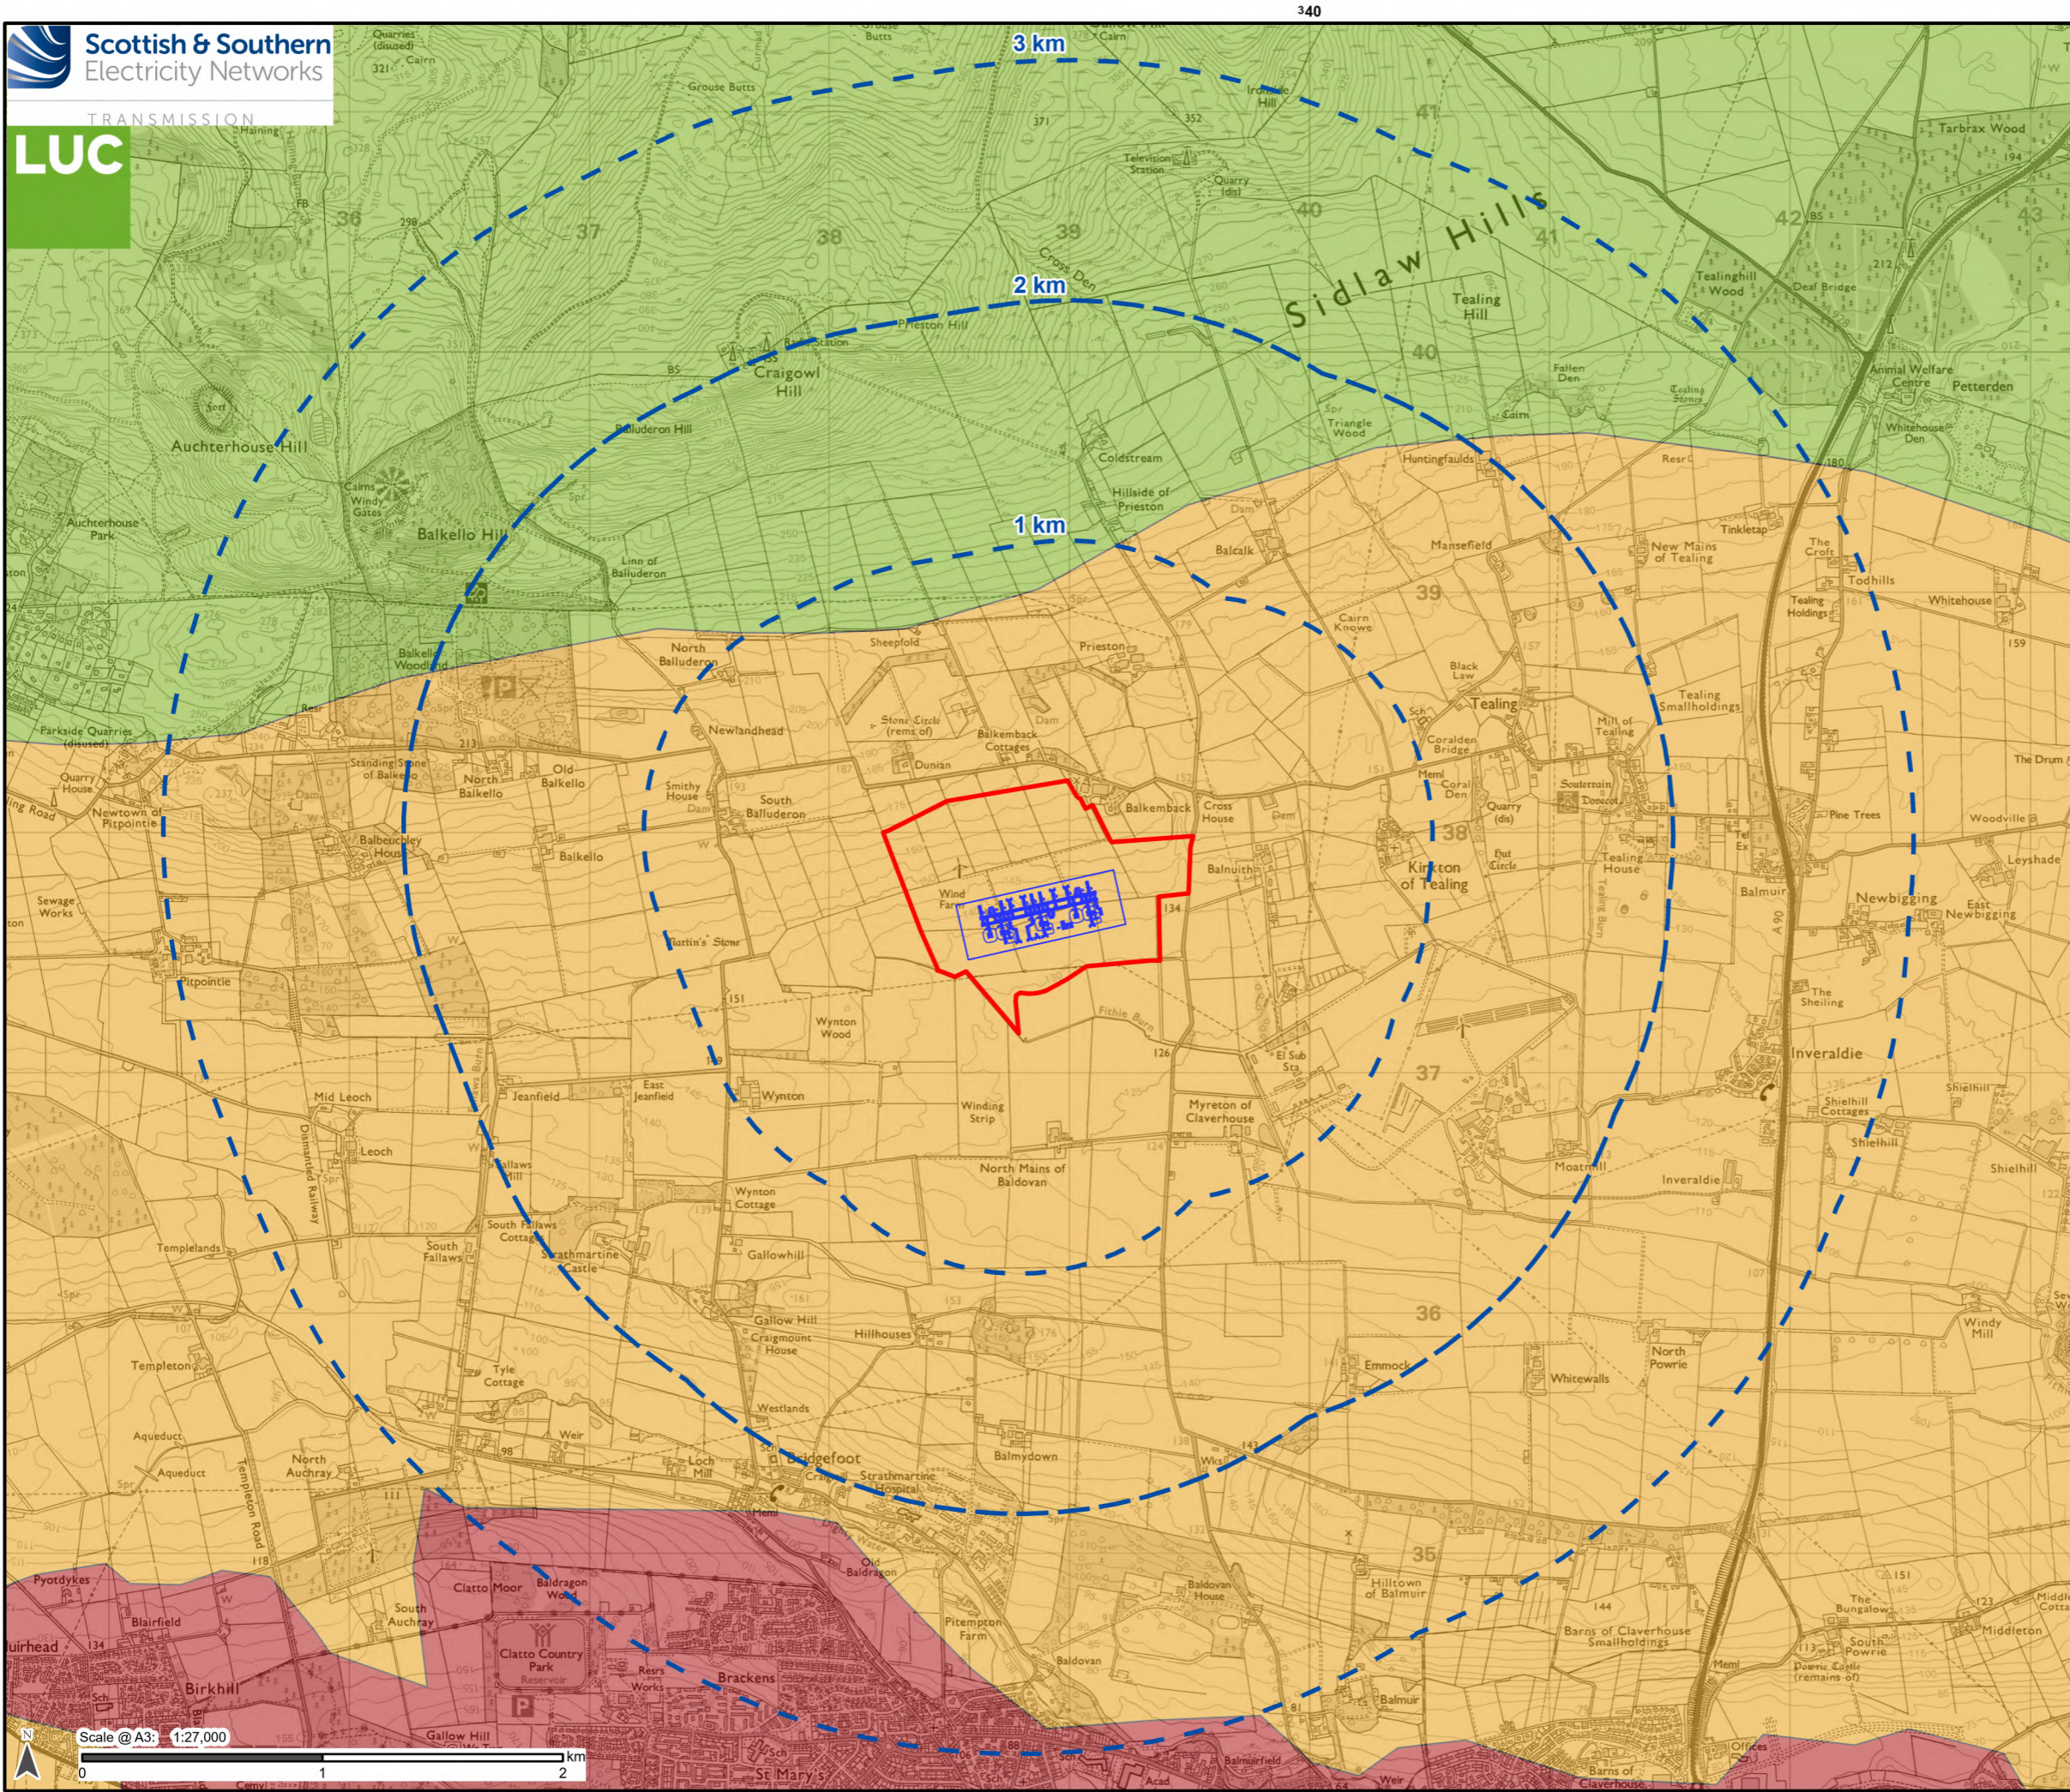


340

340

- Emmock red line boundary
  - LVIA study area boundary (3km buffer from red line boundary)
  - Electrical layout and fence line
- Landscape Character Types**
- 0: Urban
  - 382: Lowland Hill Ranges
  - 387: Dipslope Farmland

740

Contains public sector information licensed under the Open Government Licence v3.0.

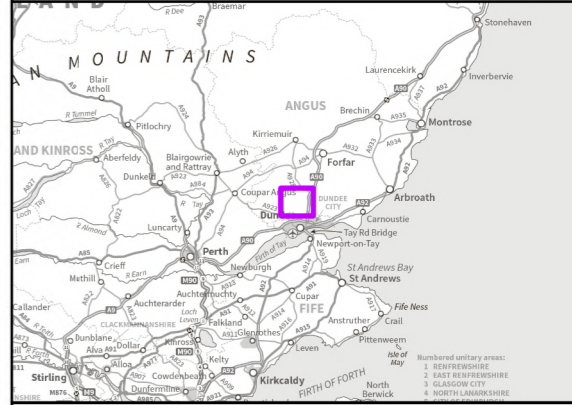

Reproduced by permission of Ordnance Survey on behalf of HMSO. Crown copyright and database right 2024 all rights reserved. Ordnance Survey Licence number 0100022432.

Project No: LT382  
Project: Emmock 400 kV Substation

Title:  
Landscape Character Types

Drawn by: IB Date: 06/11/2024

Figure: 7.3a