



- NOTES:**
- THIS DRAWING IS FOR PLANNING PURPOSES ONLY SUBJECT TO DETAILED DESIGN.
 - DO NOT SCALE FROM THIS DRAWING. USE ONLY SPECIFIED DIMENSIONS.
 - ALL DIMENSIONS ARE IN METRES UNLESS NOTED OTHERWISE.
 - ALL LEVELS ARE IN METRES TO ORDNANCE DATUM UNLESS NOTED OTHERWISE.
 - THE FOLLOWING FENCING REQUIREMENTS HAVE BEEN ASSUMED: SEE 162507-BMD-PL-HR-DPL-TP-0001.
- LEGEND:**
- PROPOSED FENCE
 - PLATFORM OUTLINE
- REFERENCE DRAWINGS:**
- ELECTRICAL SITE LAYOUT (PRIMARY) - 162507-BMD-PL-HR-DPL-TP-0001
 - ELECTRICAL ELEVATIONS - 162507-BMD-PL-HR-DEL-TP-0001
 - DRAINAGE LAYOUT FOR OPERATIONAL PHASE - 162507-BMD-CE-HR-DPL-TP-0001
 - SECURITY FENCING AND GATE LAYOUT AND DETAILS - SH 2 OF 2: - 162507-BMD-CE-HR-DDE-TP-0005

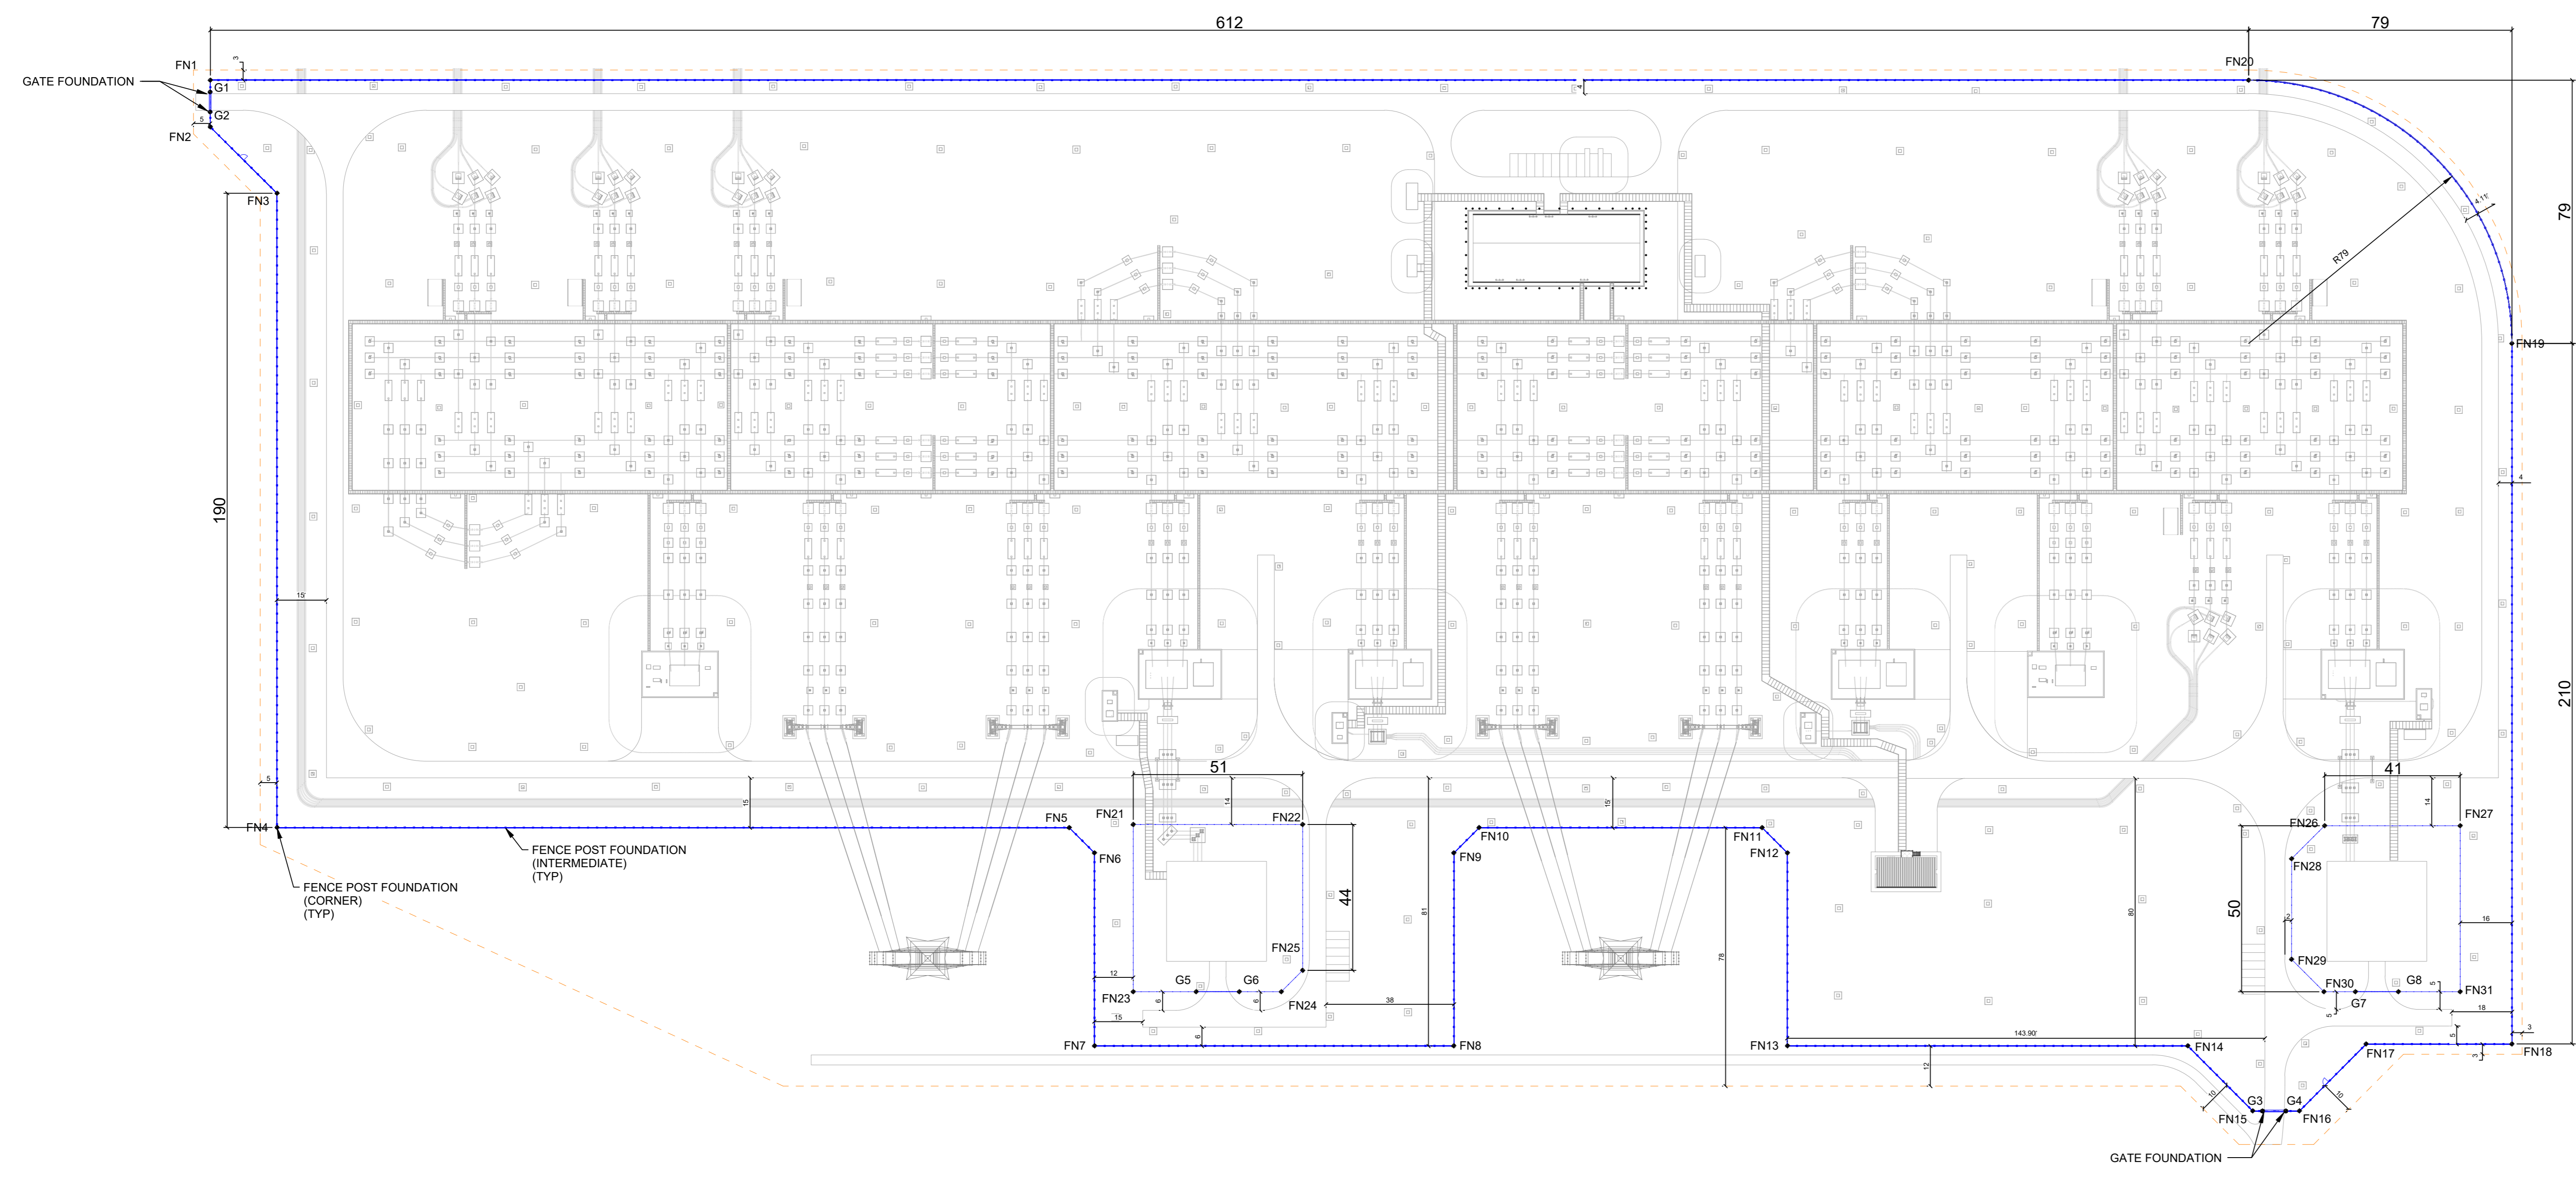

SECURITY FENCING AND GATE - LAYOUT
1:1000

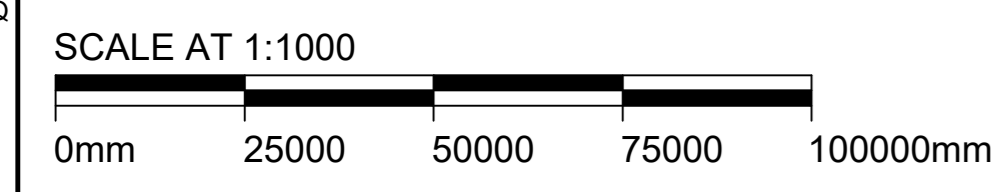

Issue / Revision:	RB	Drawn By:	RB
Investment No.:	N/A	Checked By:	JF
Date:	27/SEP/24	Approved By:	RC

Description / Remarks
ISSUED FOR PLANNING

Drawing Status: ISSUED FOR PLANNING			
Software:	Status Code:	Scale:	Paper Size:
AUTOCAD	Not Used	1:1000	A0
Drawn By:	Checked By:	Approved By:	Date:
RB	JF	RC	27/SEP/24
Contractor: BURNS & MCDONNELL <small>Burns & McDonnell Europe (UK) Limited, trading as Burns & McDonnell 2 Parklands Way, Marn Park, Marnwell, ML1 4PP, UK Email: enr@burns-mcd.com Website: www.burnsmcd.com</small>			
Client: 		Supplier / Subcontractor:	
Drawing Title: SECURITY FENCING AND GATE LAYOUT			
Project Name: HURLIE 400kV SUBSTATION			
Site Name: HURLIE 400kV SUBSTATION			
Contractor Drawing No.: 162507-BMD-CE-HR-DDE-TP-0004			
Client Drawing No.: 162507-BMD-CE-HR-DDE-TP-0004			Sheet: 1 OF 1
Supplier / Subcontractor Drawing No.: XXX			Next: 2
Issue / Revision: 01			
<small>The information in this drawing is the copyright of Burns & McDonnell Europe (UK) Limited. It must not be copied or reproduced without the express permission of Burns & McDonnell Europe (UK) Limited. © 2023 Burns & McDonnell Europe (UK) Limited.</small>			