



**GROUND FLOOR PLAN SWITCHGEAR BUILDING**

SCALE 1:100

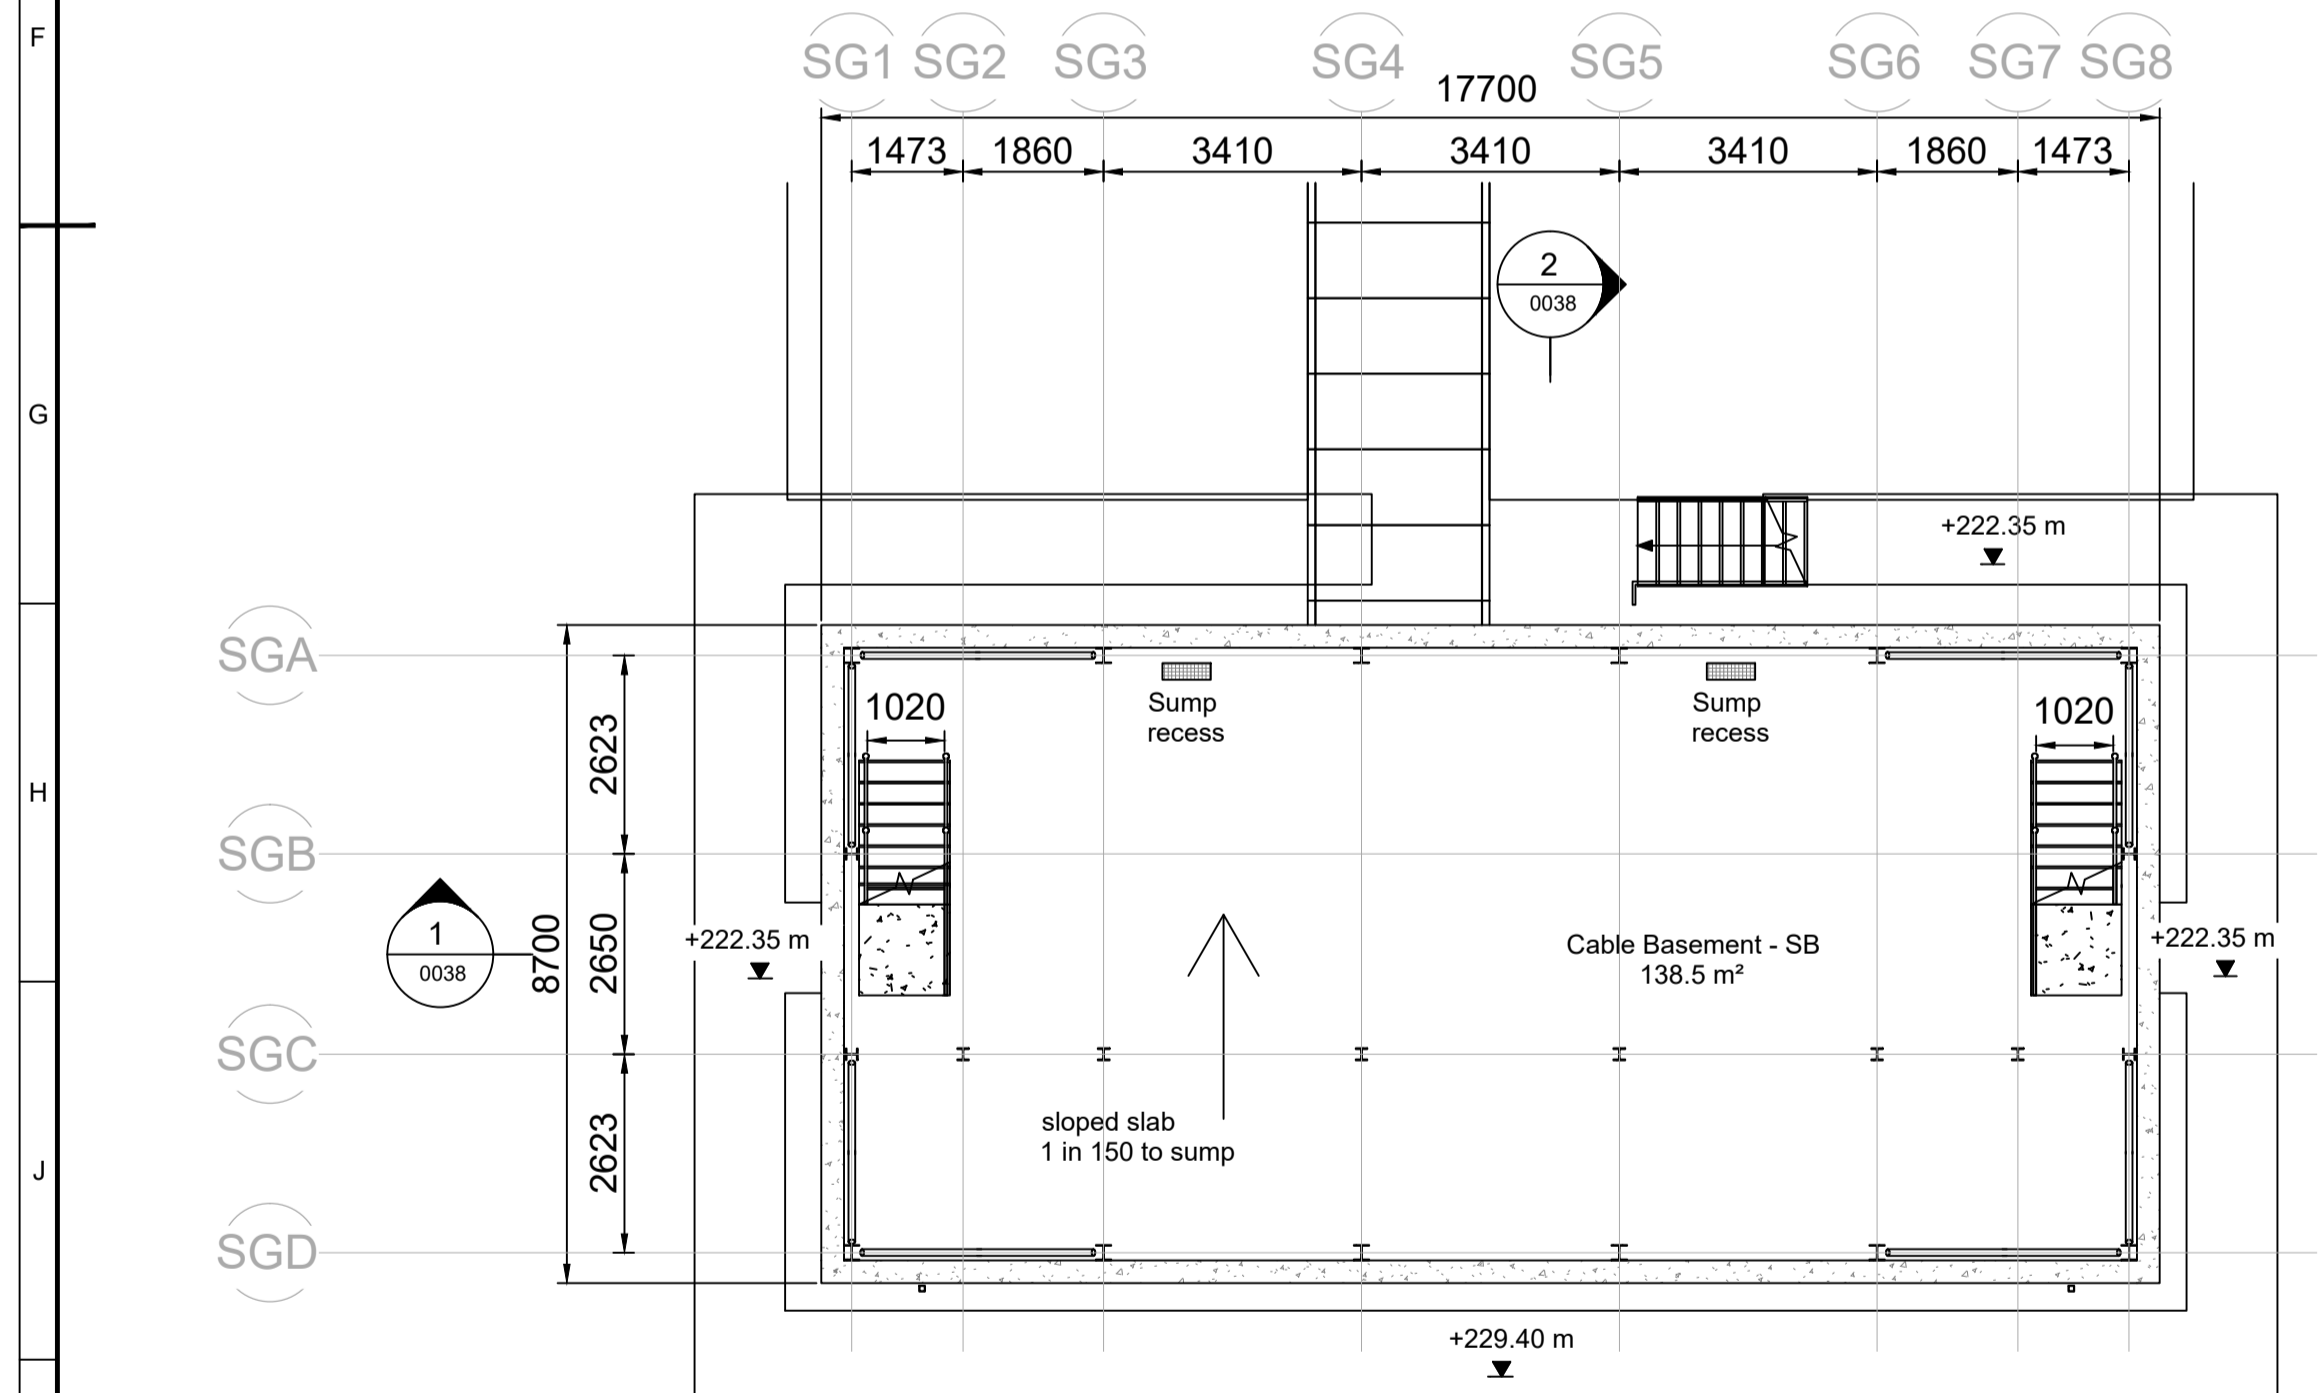

**CABLE BASEMENT PLAN SWITCHGEAR BUILDING**



SCALE 1:100

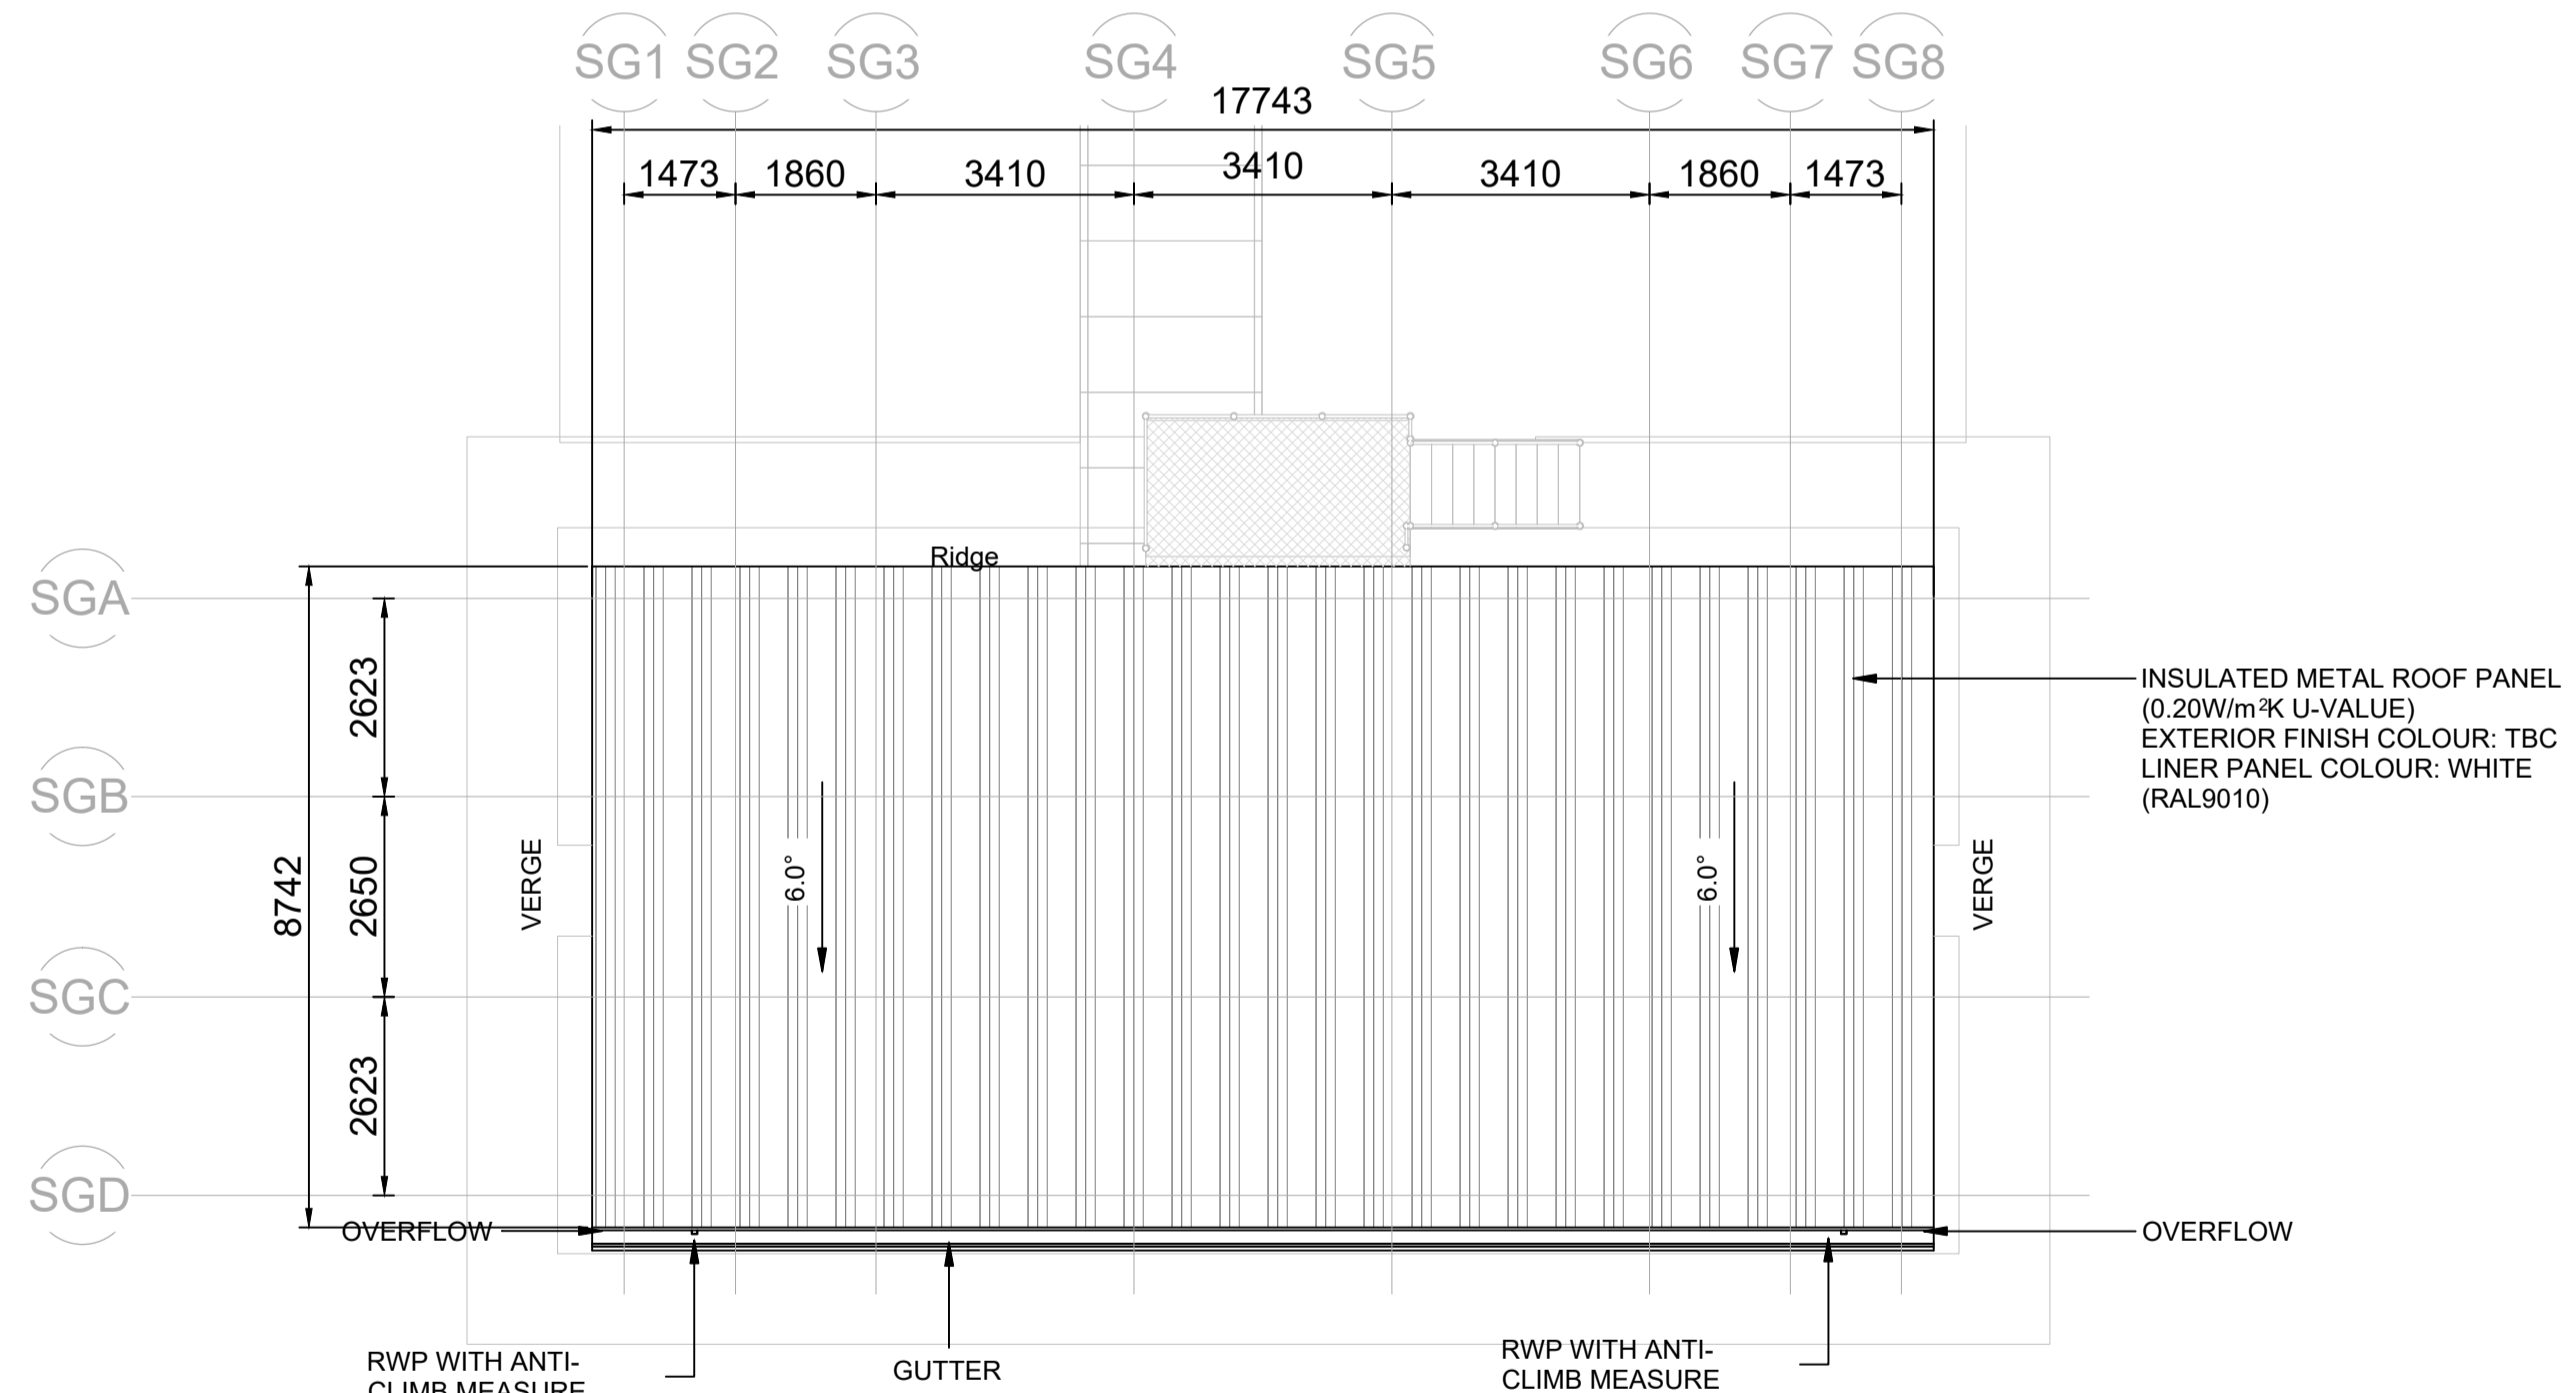

**ROOF PLAN SWITCHGEAR BUILDING**

SCALE 1:100

- NOTES:**
- THIS DRAWING IS FOR PLANNING PURPOSES ONLY SUBJECT TO DETAILED DESIGN.
  - DO NOT SCALE FROM THIS DRAWING. USE ONLY SPECIFIED DIMENSIONS.
  - ALL DIMENSIONS ARE IN MILLIMETRES UNLESS NOTED OTHERWISE.
  - ALL LEVELS ARE IN METRES TO ORDNANCE DATUM UNLESS NOTED OTHERWISE.
  - CONTROL BUILDING SHALL BE DESIGNED AND DETAILED IN ACCORDANCE WITH SP-NET-CIV- Rev1.00.

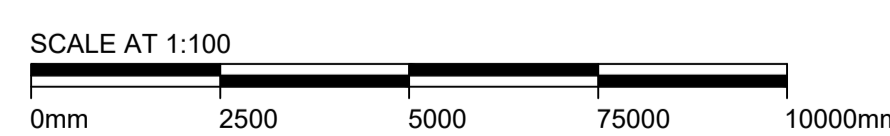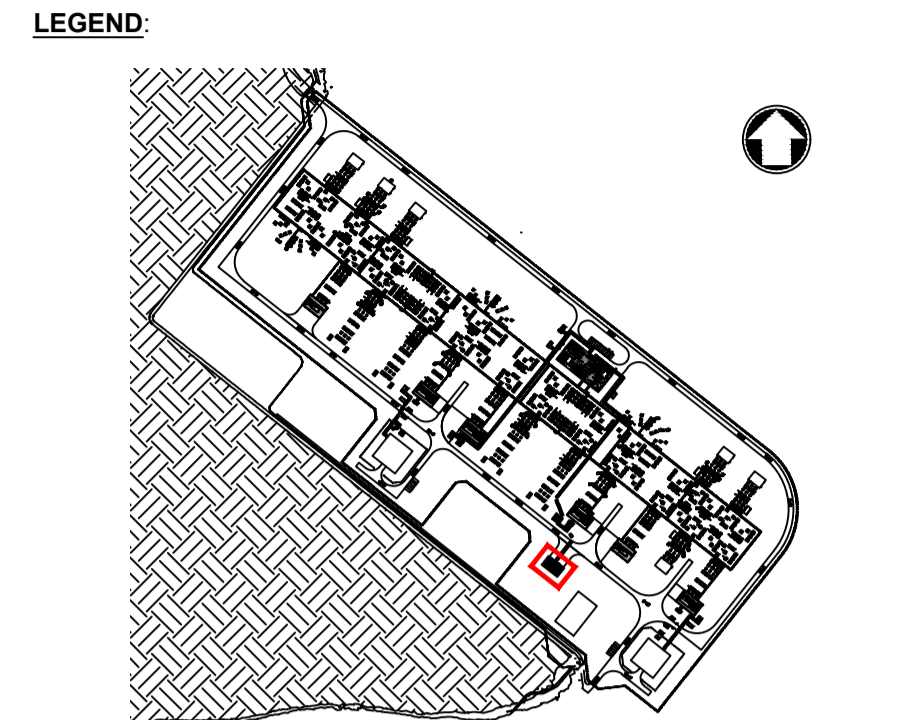

Issue / Revision:	01	Drawn By:	RB
Investment No.:	N/A	Checked By:	JF
Date:	15/NOV/24	Approved By:	RC
Description / Remarks			
FIRST ISSUE			

<b>Drawing Status:</b>			
<b>ISSUED FOR PLANNING</b>			
Software:	Status Code:	Scale:	Paper Size:
AUTOCAD	Not Used	1:100	A1
Drawn By:	Checked By:	Approved By:	Date:
RB	JF	RC	15/NOV/24
<b>Contractor:</b>			
<b>BURNS MCDONNELL</b>			
<small>Burns &amp; McDonnell Europe (UK) Limited, trading as Burns &amp; McDonnell Corporation, 2 Cornhill Street, Birmingham, B1 2JL, UK. Website: www.burnsmcd.com</small>			
<b>Client:</b>		<b>Supplier / Subcontractor:</b>	
<b>Drawing Title:</b>			
SWITCHGEAR BUILDING FLOOR PLANS			
<b>Project Name:</b>			
HURLIE 400KV SUBSTATION			
<b>Site Name:</b>			
HURLIE 400KV SUBSTATION			
<b>Contractor Drawing No.:</b>			
162507_BMD-BL-HR-DEL-TP-0005			
<b>Client Drawing No.:</b>			<b>Sheet:</b>
162507_BMD-BL-HR-DEL-TP-0005			1 OF 1
<b>Supplier / Subcontractor Drawing No.:</b>			<b>Next:</b>
XXX			-
<b>Issue / Revision:</b>			<b>Issue / Revision:</b>
01			01

The information in this drawing is the copyright of Burns & McDonnell Europe (UK) Limited. It must not be copied or reproduced without the express permission of Burns & McDonnell Europe (UK) Limited. © 2023 Burns & McDonnell Europe (UK) Limited.